


140 MOUNTAIN ROAD PROPOSED INDUSTRIAL DEVELOPMENT

THE TOWN OF COLLINGWOOD

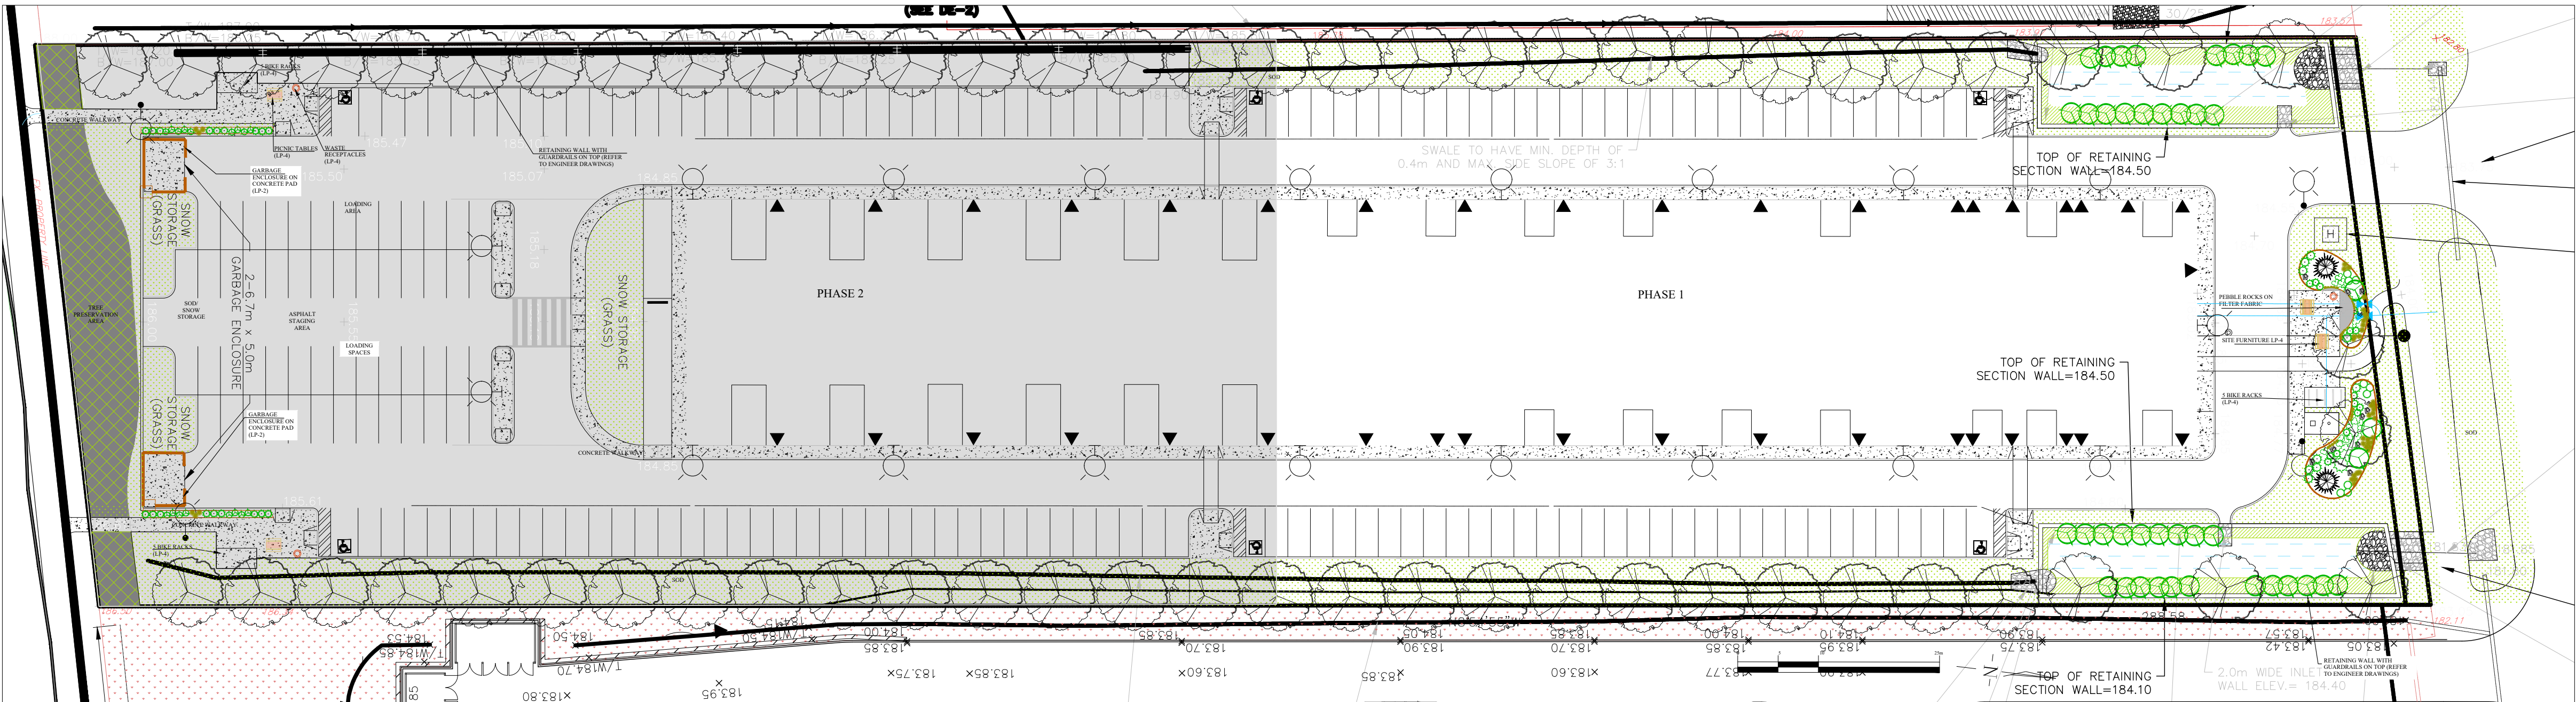


140 MOUNTAIN ROAD REFERENCE PLAN

SCALE 1 : 500

LANDSCAPE DRAWINGS

- TP-1 TREE INVENTORY/ PRESERVATION PLAN
- TP-2 TREE PRESERVATION DETAILS
- LP-1 LANDSCAPE PLAN
- LP-2 LANDSCAPE PLAN DETAILS
- LP-3 PLANTING DETAILS
- LP-4 SITE FURNITURE AND PAVING DETAILS

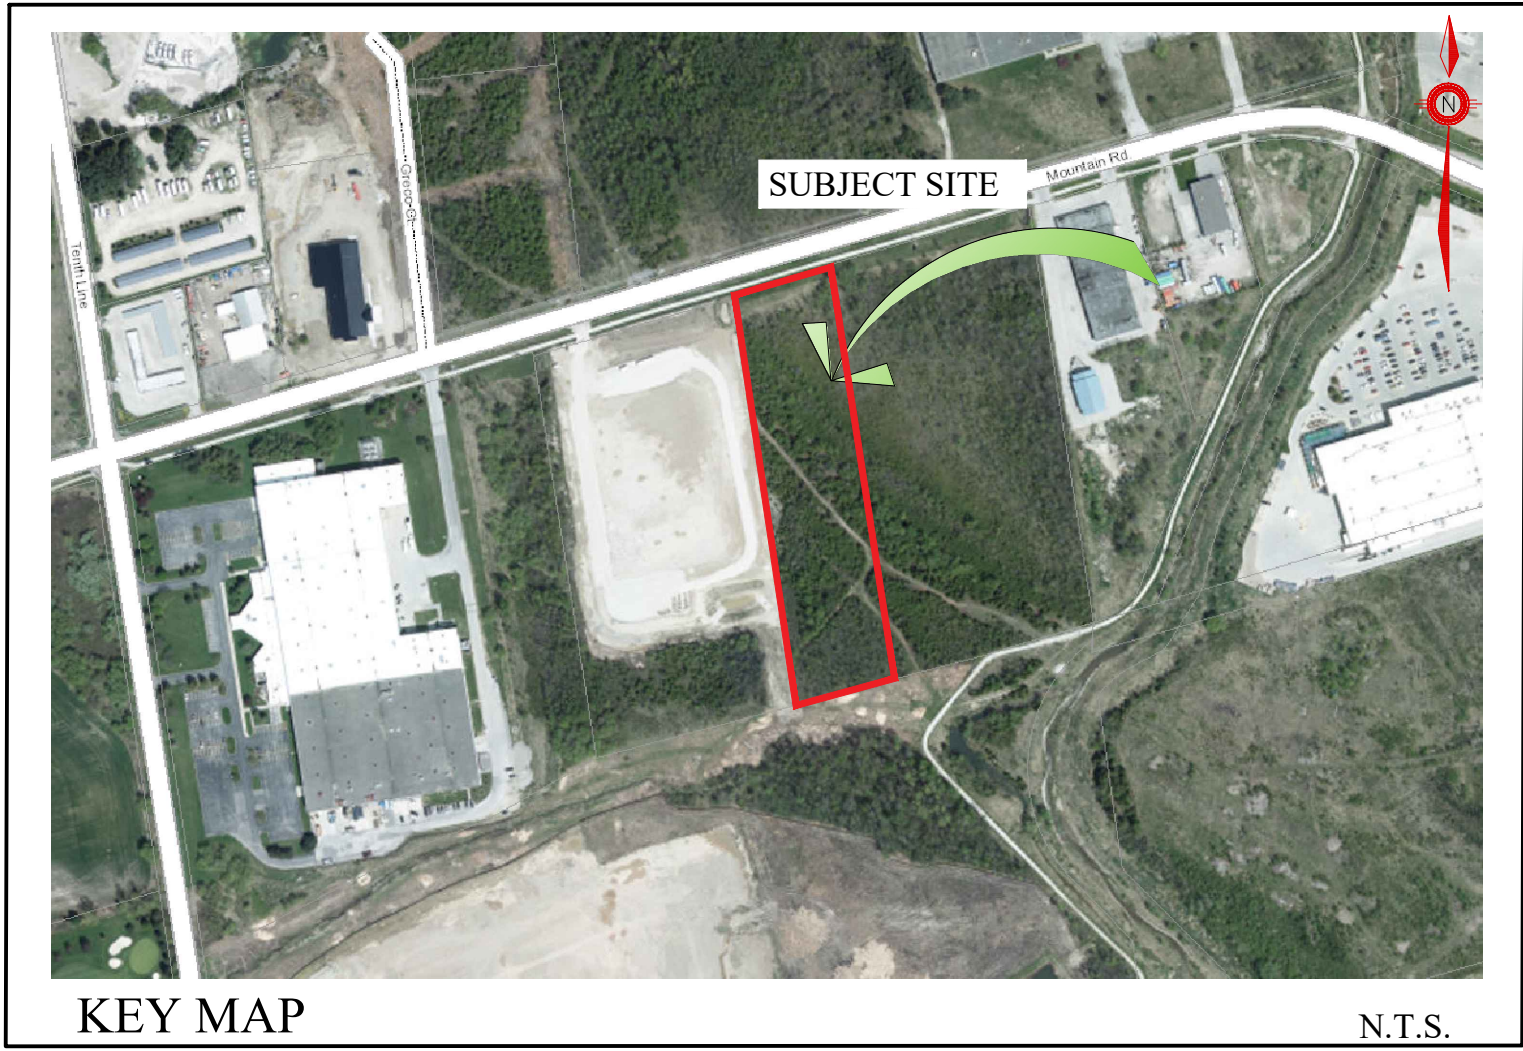


KEY MAP

N.T.S.


JDB ASSOCIATES LTD.

Urban Designers
Landscape Architects
Arborealists

274 Burton Ave., Suite 1201
Barrie, Ontario
L4N 5H4

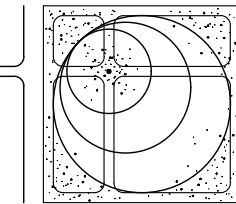

Fax: 705-722-5660
Tel: 705-722-6278

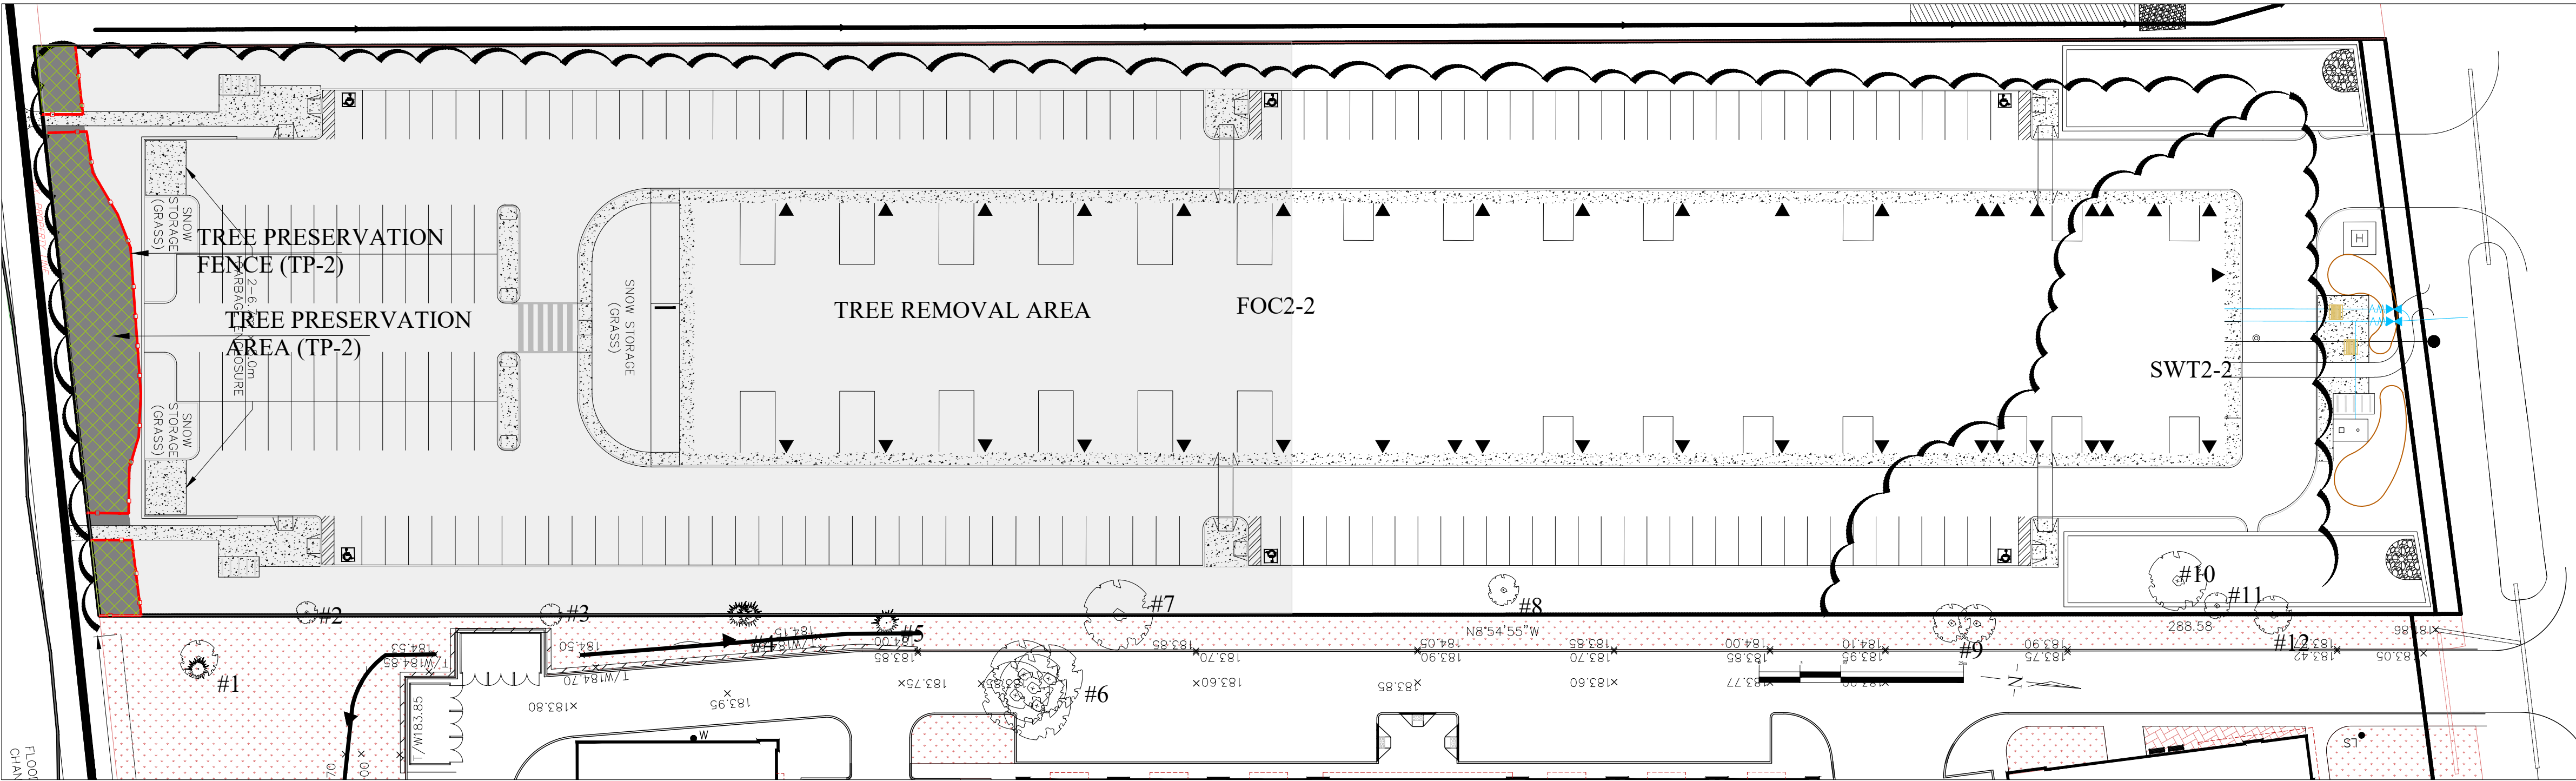

LANDSCAPE PLAN

SCALE: 1:500

140 Mountain Rd., February 17, 2022 - TREE INVENTORY

Tree #	Nr. of Trees	Botanical Name	Common name	DBH	Height	Crown Ø (m)	Maturity	Health conditions
1	1	<i>Populus balsamifera</i>	Balsam Poplar	21	8	3	Immature	Fair
	1	<i>Thuja occidentalis</i>	Eastern White Cedar	12	8	2	Immature	Fair
2	1	<i>Fraxinus pennsylvanica</i>	Green Ash	14	10	4	Immature	Fair
3	1	<i>Betula papyrifera</i>	White Birch	13	10	2	Immature	Fair
4	2	<i>Thuja occidentalis</i>	Eastern White Cedar	21	7	3	Immature	Fair
5	1	<i>Picea glauca</i>	White Spruce	19	8	3	Immature	Fair
6	5	<i>Populus tremuloides</i>	Trembling Aspen	≤30	12	7	Mature	Fair
7	1	<i>Populus tremuloides</i>	Trembling Aspen	28	12	8	Mature	Fair
8	1	<i>Betula papyrifera</i>	White Birch	10	8	3	Immature	Fair
9	2	<i>Fraxinus pennsylvanica</i>	Green Ash	16&2	≤10	4	Immature	Poor
10	1	<i>Fraxinus pennsylvanica</i>	Green Ash	15 & 20	10	7	Immature	Fair
11	1	<i>Ulmus americana</i>	American Elm	13	6	2	Immature	Fair/Poor
12	1	<i>Fraxinus pennsylvanica</i>	Green Ash	16	8	4	Immature	Fair


140 Mountain Rd., February 17, 2022 - VEGETATION COMMUNITIES

(*Refer to EIS by Roots Environmental August 9, 2021)

Veg. ID ⁷⁾	Canopy cover. %	Species	Freq.	DBH	Height	Crown Ø (m)	Maturity	Health conditions	
			%	cm	m				
SWT2-2	30	<i>Fraxinus pennsylvanica</i>	40	≤30	≤14	≤6	Uneven aged	Fair	
		<i>Ulmus americana</i>	10	≤25	≤12	≤6			
		<i>Populus balsamifera</i>	40	≤25	≤10	≤6			
		<i>Pinus sylvestris</i>	10	+/- 10	≤6	≤3	Immature		
FOC2-2	80	<i>Thuja occidentalis</i>	50	≤10	≤10	≤3	Immature	Fair	
		<i>Populus balsamifera</i>	4	≤25	≤10	≤6	Uneven aged		
		<i>Populus tremuloides</i>	10	≤20	≤8	≤4			
		<i>Betula papyrifera</i>	15	≤20	≤14	≤6			
		<i>Pinus sylvestris</i>	20	≤15	≤10	≤5			Immature
		<i>Fraxinus pennsylvanica</i>	1	≤10	≤10	≤3			

- PROPERTY LINE (SITE PLAN)
- EXISTING BOUNDARY TREES TO BE REMOVED. REFER TO TREE INVENTORY LIST.
- TREE PRESERVATION FENCE AS PER BSD-1232 ON TP-3.
- TREE GROUP TO BE PRESERVED.
- TREE GROUP TO BE REMOVED.

LEGEND

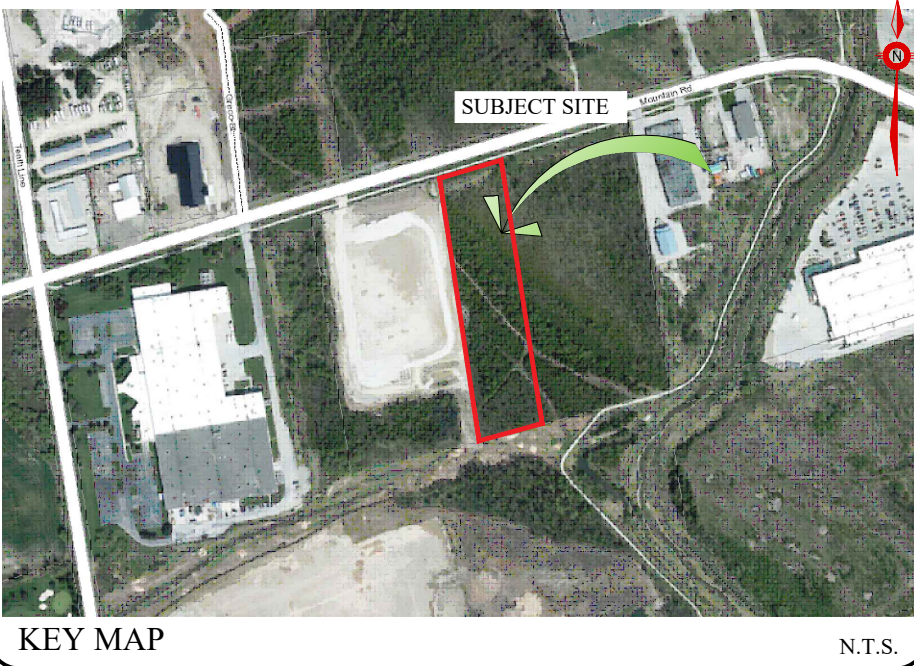

GENERAL NOTES

CONTRACTOR IS RESPONSIBLE FOR ALL LOCATES INCLUDING ALL UNDERGROUND SERVICES PRIOR TO ANY EXCAVATION OR INSTALLATIONS. THE CONTRACTOR IS REQUIRED TO NOTIFY THE VARIOUS UTILITY COMPANIES 48 HOURS PRIOR TO THE COMMENCEMENT OF ANY WORK.

ANY ACCOMPANYING DOCUMENTATION RELATING TO THE LANDSCAPE PLAN AND/OR PRESERVATION PLAN SUCH AS TENDER DOCUMENTS AND CHANGE NOTICES ARE TO BE ENDORSED BY J.D.B. ASSOCIATES LIMITED PRIOR TO THE BEGINNING OF ANY SITE WORKS. IN THE EVENT THAT OF A DISCREPANCY THE DRAWING SHALL BE ASSUMED CORRECT.

IT IS THE RESPONSIBILITY OF THE PERSON OR PERSONS RESPONSIBLE FOR THE CONSTRUCTED WORKS TO NOTIFY THE LANDSCAPE ARCHITECT WHEN PREPARED FOR ANY REQUIRED INSPECTIONS AND SIGN OFFS.

SCHEDULED MEETINGS SHALL TAKE PLACE AT THE CLOSEST MUTUALLY CONVENIENT TIME.

No.	REVISION	DATE	APRVD.
1.	CLIENT REVIEW	November 25, 2020	SJT
2.	SITE PLAN REVISIONS	August 09, 2023	SJT
3.	REVISIONS AS PER TOWN COMMENTS	August 31, 2023	SJT
4.	SITE PLAN REVISIONS	April 9, 2024	SJT
5.	REVISIONS AS PER TOWN COMMENTS	September 4, 2024	SJT

ALL DRAWINGS AND SPECIFICATIONS ARE INSTRUMENTS OF SERVICE AND ARE THE PROPERTY OF JDB ASSOCIATES LIMITED. DRAWINGS ARE NOT TO BE MODIFIED AND/OR REPRODUCED WITHOUT THE WRITTEN CONSENT OF JDB ASSOCIATES LIMITED. REPRODUCTION OF DRAWINGS IN ANY FORM WITHOUT THE CONSENT OF JDB ASSOCIATES LIMITED VOIDS THE DRAWING AT WHICH TIME JDB ASSOCIATES LIMITED ACCEPTS NO LIABILITY FOR THE DRAWING CONTENT OR WORKS RESULTING FROM SAID REPRODUCTION. DRAWINGS MAY BE REPRODUCED BY MUNICIPAL AND GOVERNMENT AGENCIES RESPONSIBLE FOR APPROVALS FOR THEIR OWN USE. JDB ASSOCIATES RESERVES THE RIGHT TO WITHDRAW ANY DRAWING(S) FROM GOVERNMENT OR MUNICIPAL AGENCIES WHETHER APPROVED OR NOT IN THE EVENT THAT ACCOUNTS ARE NOT SETTLED OR REMAIN OUTSTANDING.

IT IS THE RESPONSIBILITY OF THE CONTRACTOR TO VERIFY ALL DIMENSIONS ON THE SITE AND REPORT ANY DISCREPANCIES OR VARIATIONS FROM THE SUPPLIED INFORMATION TO THE LANDSCAPE ARCHITECT WITH THE PROJECT. JDB ASSOCIATES LIMITED IS NOT RESPONSIBLE FOR THE ACCURACY OF SURVEY, ARCHITECTURAL, MECHANICAL, ENGINEERING OR ELECTRICAL INFORMATION SHOWN ON THE DRAWING. FOR FURTHER INFORMATION REFER TO APPROPRIATE SURVEY, ARCHITECTURAL, MECHANICAL, ENGINEERING OR ELECTRICAL DRAWINGS PRIOR TO PROCEEDING WITH ANY WORKS.

THIS DRAWING IS NOT TO BE SCALED.



BASE PLAN REVISED-JUNE 2022

Client info:

APPROVED

DATE

LANDSCAPE ARCHITECTS STAMP
STAMP AND ARCHITECTS SIGNATURE REQUIRED

JDB ASSOCIATES LTD.

Urban Designers
Landscape Architects
Arborists

274 Burton Ave., Suite 1201
Barrie, Ontario
L4N 5W4

Fax: 705-722-5660
Tel: 705-722-6278

140 Mountain Rd.
Town of Collingwood
INDUSTRIAL BUILDING

TREE INVENTORY/PRESERVATION PLAN

SCALE: AS SHOWN	DATE:	DESIGNED BY: SJT	REVIEWED BY: NB
TOWN FILE No. D00921	OUR FILE REF. # 1-22	DRAWN BY: SJT	TP-1

THE INTENT OF TREE PRESERVATION AND PROTECTION IS TO PROVIDE AN INVENTORY OF EXISTING TREES ON SITE. IT IS NOT A SURVEY AND THEREFORE THE EXACT LOCATION OF EXISTING TREES MUST BE VERIFIED ON SITE PRIOR TO THE COMMENCEMENT OF ANY CONSTRUCTION WORKS.

ALL TREES TO BE PRESERVED SHALL BE INDICATED AND MARKED AS SUCH ON SITE BY THE LANDSCAPE ARCHITECT PRIOR TO THE SITE DEVELOPMENT.

AS PART OF THE CLEARING AND GRUBBING, TREES LOCATED AT THE EDGES OF STANDS ABUTTING RESIDENTIAL ARE ARE TO BE PRUNED OF DEAD AND DISEASED LIMBS. PRUNING TO BE COMPLETED IN ACCORDANCE TO ACCEPTED HORTICULTURAL PRACTICES AND TO THE SATISFACTION OF THE LANDSCAPE ARCHITECT.

IN THE EVENT THAT A TREE THAT HAS BEEN DESIGNATED FOR PRESERVATION IS DAMAGED OR REMOVED WITHOUT PRIOR WRITTEN PERMISSION FROM THE TOWN, THE LAND OWNER SHALL BE RESPONSIBLE FOR THE REPLACEMENT OF SAID TREE WITH TREES OF EQUAL CALIPER VALUE AND COMPARABLE SPECIES, TO THE SATISFACTION OF THE THE TOWN AND THE LANDSCAPE ARCHITECT.

SPECIFICATIONS FOR PRESERVATION & PROTECTION

PRIOR THE COMMENCEMENT OF ANY CONSTRUCTION WORKS, ALL TREES OR BLOCKS OF TREES THAT HAVE BEEN DESIGNATED FOR PRESERVATION, AS INDICATED ON THE ACCOMPANYING PLAN SHALL BE FULLY PROTECTED BY THE ERECTION OF HOARDING OUTSIDE OF OR AT THE DRIP LINE (SEE DETAIL). AREAS WITHIN THE HOARDING SHALL BE CLEARED AND GRUBBED ONLY UNDER THE WRITTEN DIRECTION AND SUPERVISION OF THE LANDSCAPE ARCHITECT.

EQUIPMENT OR VEHICLES SHALL NOT BE PARKED, REPAIRED OR REFUELED WITHIN TREE PROTECTION ZONE, CONSTRUCTION MATERIALS SHALL NOT BE STORED AND EARTH MATERIALS SHALL NOT BE STOCKPILED WITHIN THE DRIP LINE AREA OF ANY TREE NOT DESIGNATED FOR REMOVAL.

ANY TREES NOT DESIGNATED FOR REMOVAL SHALL NOT HAVE RIGGING CABLES ATTACHED OR WRAPPED AROUND THEM NOR SHALL ANY CONTAMINANTS BE DUMPED WITHIN THE PROTECTIVE AREAS. FURTHER, NO CONTAMINANTS SHALL BE DUMPED OR FLUSHED WHERE THEY MAY COME INTO CONTACT WITH THE FEEDER ROOTS OF THE TREES TO BE PRESERVED.

THE CONTRACTOR OR LAND OWNER SHALL TAKE EVERY PRECAUTION TO PREVENT DAMAGE TO TREES OR SHRUBS THAT ARE NOT DESIGNATED FOR REMOVAL AS PER THE ACCOMPANYING PLAN.

UNLESS THE CONTRACT WORK SPECIFICALLY REQUIRES WORK WITHIN THE DRIP LINE OF TREES NOT DESIGNATED FOR REMOVAL, EQUIPMENT SHALL NOT BE OPERATED WITHIN THAT DRIP LINE AREA. WHEN CONTRACT WORK MUST BE COMPLETED WITHIN THE DRIP LINE OF TREES NOT DESIGNATED FOR REMOVAL, OPERATION OF EQUIPMENT WITHIN THAT DRIP LINE SHALL BE KEPT TO THE MINIMUM AMOUNT REQUIRED TO COMPLETE THE WORKS. PRIOR TO THE COMMENCEMENT OF SUCH WORKS THE LANDSCAPE ARCHITECT MUST BE GIVEN WRITTEN NOTIFICATION AND WILL SUBSEQUENTLY BE REQUIRED TO INSPECT SAID WORKS.


THE CONTRACTOR'S OPERATION SHALL IN NO WAY CAUSE DAMAGE TO THE TRUNK OR BRANCHES OF TREES NOT DESIGNATED FOR REMOVAL.

THE CONTRACTOR'S OPERATION SHALL NOT CAUSE FLOODING OR SEDIMENT DEPOSITS IN AREAS WHERE TREES ARE NOT DESIGNATED FOR REMOVAL.

IN THE EVENT THAT IT IS NECESSARY TO REMOVE LIMBS OR PORTIONS OF TREES NOT DESIGNATED FOR REMOVAL, WRITTEN APPROVAL AND DIRECTION MUST BE GIVEN BY THE LANDSCAPE ARCHITECT PRIOR TO ANY WORKS. THE REMOVALS MUST BE EXECUTED CAREFULLY AND IN ACCORDANCE WITH STANDARD HORTICULTURAL PRACTICES AND TECHNIQUES.

NO GRADING SHALL TAKE PLACE WITHIN THE PRESERVATION ZONE.

NOTES FOR PRESERVATION AND PROTECTION

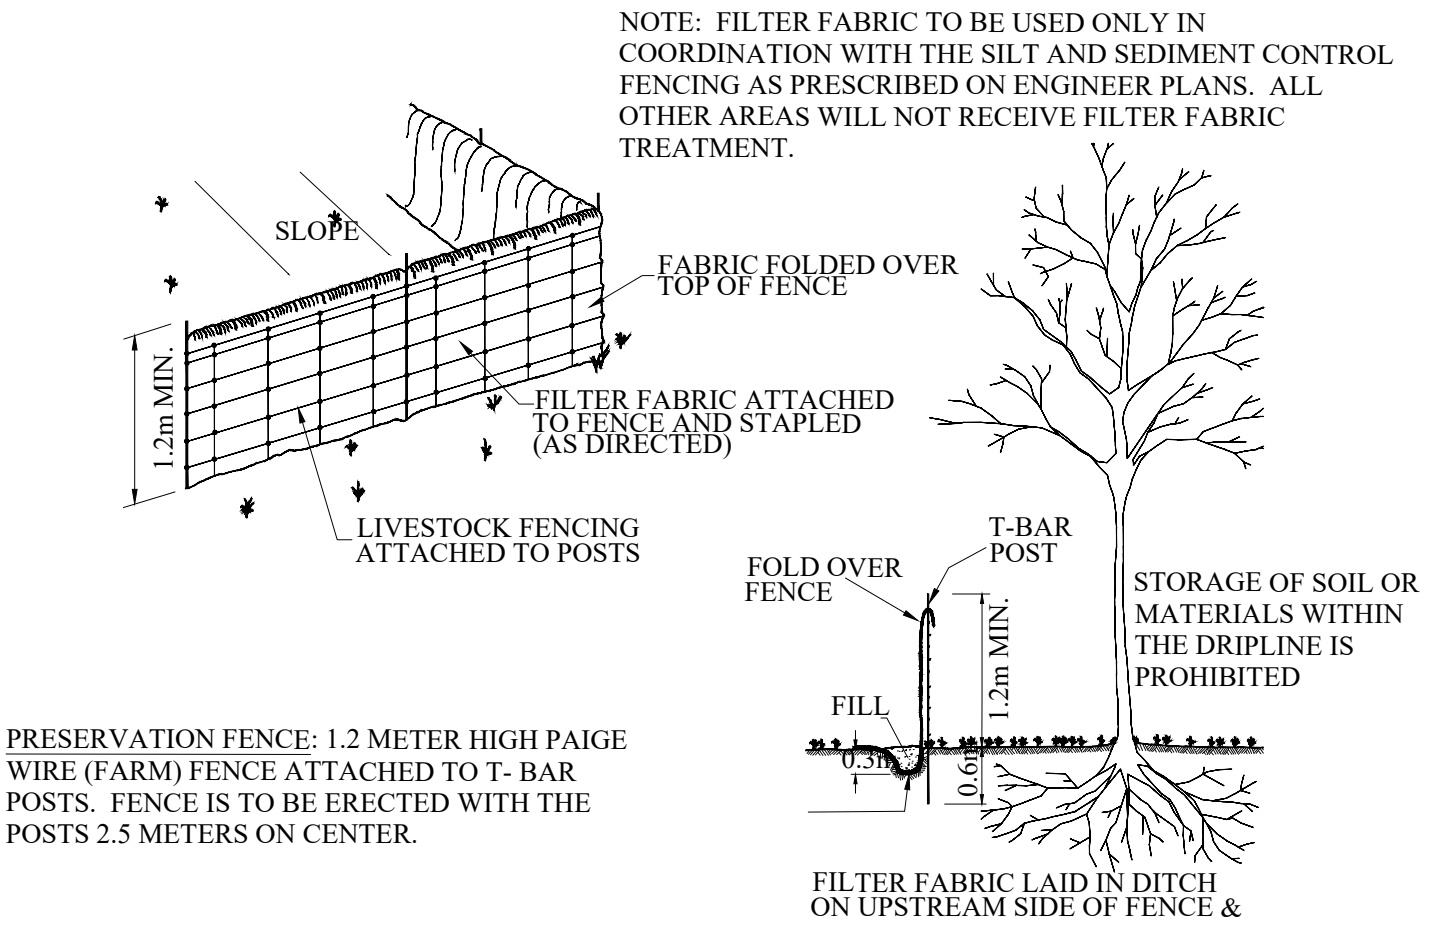


D1 - TREE PRESERVATION FENCE


1. PROTECTION AREA IS INITIALLY IDENTIFIED IN THE FIELD BY A LICENSED ONTARIO SURVEYOR. THIS LINE APPROXIMATELY ESTABLISHES THE LIMITS OF TREE PRESERVATION SUBJECT TO AN ON-SITE MEETING WITH TOWN OF COLLINGWOOD PARKS PLANNING STAFF AND THE LANDSCAPE ARCHITECT/ARBORIST.
2. THE LANDSCAPE ARCHITECT/ARBORIST AND THE TOWN OF COLLINGWOOD PARKS PLANNING STAFF MEET TO REVIEW THE SURVEYED LINE PRIOR TO ANY TREE REMOVAL OCCURRING, AND TO ADJUST THE LINE WHERE APPROPRIATE TO REFLECT THE ACTUAL NATURE OF A TREED AREA AS OPPOSED TO A STRAIGHT CUT LINE.
3. TREES THAT ARE SUSCEPTIBLE TO FALLING ONTO PRIVATE PROPERTY OR MUNICIPAL PROPERTY FROM WITHIN THE TREE PRESERVATION ZONE WILL BE IDENTIFIED FOR REMOVAL. REMOVAL WILL TAKE PLACE AS PRESCRIBED IN ITEM #6 BELOW.
4. ONCE THE SITE VISIT HAS CONCLUDED, THEN TREE PRESERVATION FENCING WILL BE ERECTED ALONG THE AGREED TREE PRESERVATION LINE.
5. FULL TREE REMOVAL OUTSIDE OF THE TREED AREAS MAY OCCUR ONCE THE PRESERVATION FENCING HAS BEEN ERECTED AND ALL REQUIRED TREE REMOVAL PERMITTING IS ISSUED.
6. TREES ARE TO BE FELLED IN SUCH A MANNER AS TO NOT DISTURB VEGETATION TO REMAIN. NO MACHINERY OR EQUIPMENT SHALL BE OPERATED OR STORED WITHIN THE DRIPLINE OF PROTECTED TREES.
7. STUMP REMOVALS ARE TO BE IMPLEMENTED AS TO NOT TO DISTURB THE GROUND WITHIN THE TREE PRESERVATION ZONE.
8. ONCE TREE REMOVAL HAS OCCURRED, AND PRIOR TO THE ISSUANCE OF THE UNDERGROUND CERTIFICATE, A RE-INSPECTION OF THE TREE PRESERVATION AREAS MUST OCCUR WITH TOWN OF COLLINGWOOD STAFF AND THE LANDSCAPE ARCHITECT/ARBORIST. ANY ADDITIONAL TREES TO BE REMOVED WILL BE NOTED BY THE TOWN OF COLLINGWOOD PARKS PLANNING STAFF AND LANDSCAPE ARCHITECT/ ARBORIST.
9. ALL TREES ON ADJACENT PRIVATE LAND SHALL RECEIVE DRIPLINE PROTECTION.

TREE PRESERVATION PROCESS

NOTE:
NO TREE CUTTING SHALL OCCUR BETWEEN APRIL 1st AND OCTOBER 31st UNLESS CLEARANCE FROM M.N.R. AND M.E.C.P. IS PROVIDED.

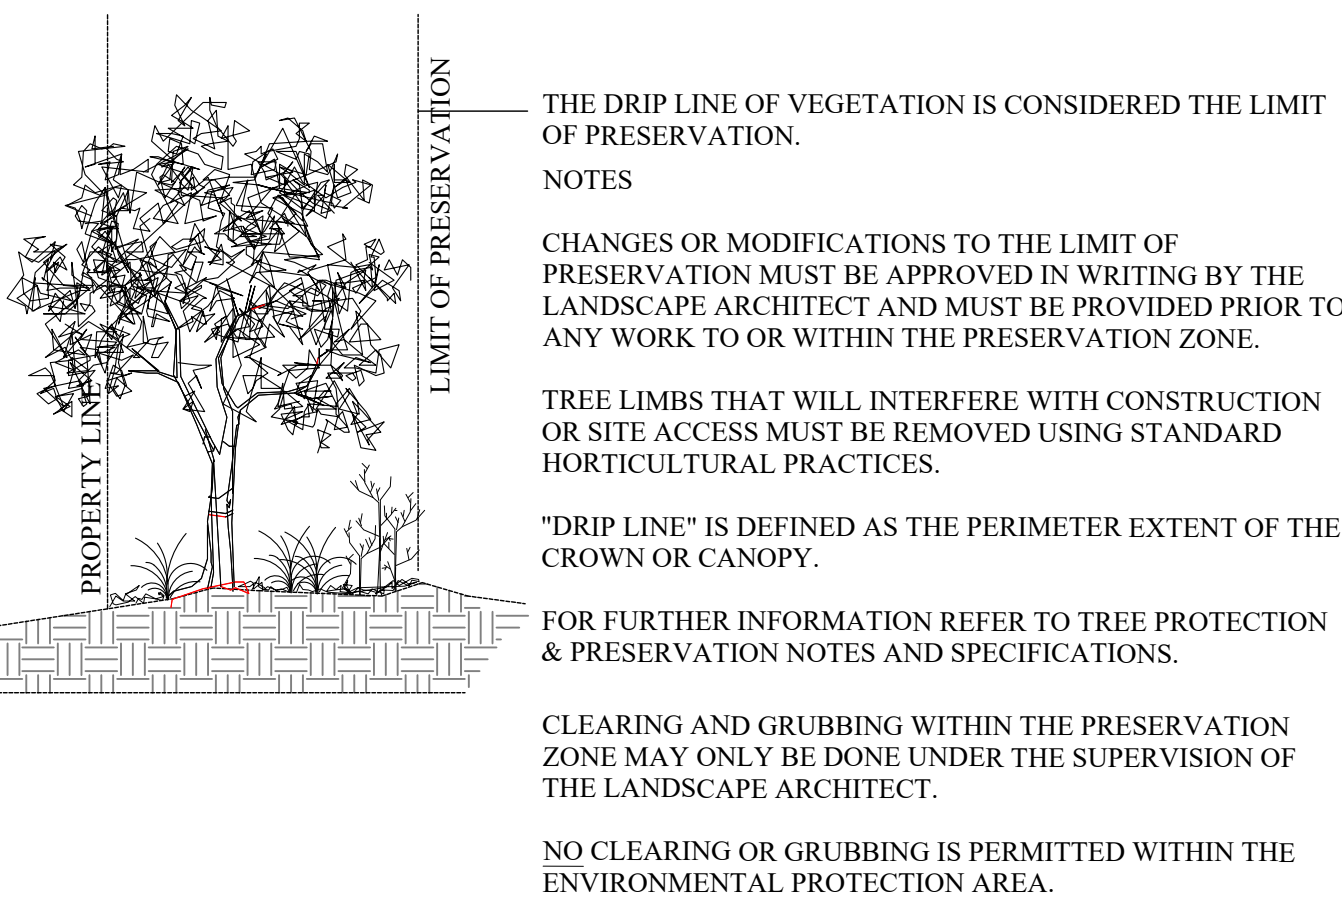

D2 - LIMIT OF TREE PRESERVATION DETAIL

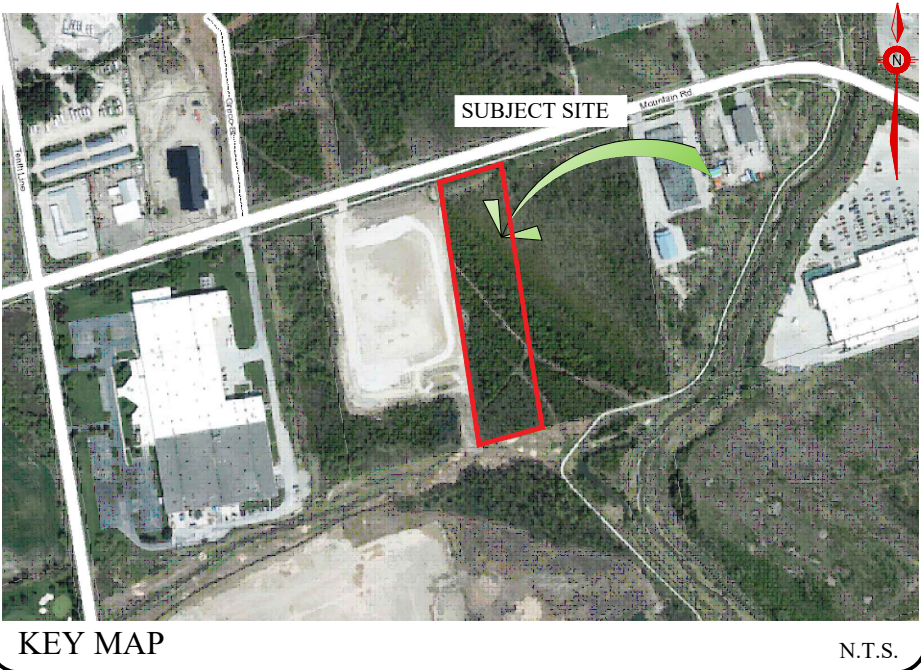

GENERAL NOTES

CONTRACTOR IS RESPONSIBLE FOR ALL LOCATES INCLUDING ALL UNDERGROUND SERVICES PRIOR TO ANY EXCAVATION OR INSTALLATIONS. THE CONTRACTOR IS REQUIRED TO NOTIFY THE VARIOUS UTILITY COMPANIES 48 HOURS PRIOR TO THE COMMENCEMENT OF ANY WORK.

ANY ACCOMPANYING DOCUMENTATION RELATING TO THE LANDSCAPE PLAN AND/OR PRESERVATION PLAN SUCH AS TENDER DOCUMENTS AND CHANGE NOTICES ARE TO BE ENDORSED BY J.D.B. ASSOCIATES LIMITED PRIOR TO THE BEGINNING OF ANY SITE WORKS. IN THE EVENT THAT OF A DISCREPANCY THE DRAWING SHALL BE ASSUMED CORRECT.

IT IS THE RESPONSIBILITY OF THE PERSON OR PERSONS RESPONSIBLE FOR THE CONSTRUCTED WORKS TO NOTIFY THE LANDSCAPE ARCHITECT WHEN PREPARED FOR ANY REQUIRED INSPECTIONS AND SIGN OFFS.

SCHEDULED MEETINGS SHALL TAKE PLACE AT THE CLOSEST MUTUALLY CONVENIENT TIME.

No.	REVISION	DATE	APRVD.
1.	CLIENT REVIEW	November 25, 2020	SJT
2.	SITE PLAN REVISIONS	August 09, 2023	SJT
3.	REVISIONS AS PER TOWN COMMENTS	August 31, 2023	SJT
4.	SITE PLAN REVISIONS	April 9, 2024	SJT
5.	REVISIONS AS PER TOWN COMMENTS	September 4, 2024	SJT

ALL DRAWINGS AND SPECIFICATIONS ARE INSTRUMENTS OF SERVICE AND ARE THE PROPERTY OF JDB ASSOCIATES LIMITED. DRAWINGS ARE NOT TO BE MODIFIED AND/OR REPRODUCED WITHOUT THE WRITTEN CONSENT OF JDB ASSOCIATES LIMITED. REPRODUCTION OF DRAWINGS IN ANY FORM WITHOUT THE CONSENT OF JDB ASSOCIATES LIMITED VOIDS THE DRAWING AT WHICH TIME JDB ASSOCIATES LIMITED ACCEPTS NO LIABILITY FOR THE DRAWING CONTENT OR WORKS RESULTING FROM SAID REPRODUCTION. DRAWINGS MAY BE REPRODUCED BY MUNICIPAL AND GOVERNMENT AGENCIES RESPONSIBLE FOR APPROVALS FOR THEIR OWN USE. JDB ASSOCIATES RESERVES THE RIGHT TO WITHDRAW ANY DRAWING(S) FROM GOVERNMENT OR MUNICIPAL AGENCIES WHETHER APPROVED OR NOT IN THE EVENT THAT ACCOUNTS ARE NOT SETTLED OR REMAIN OUTSTANDING.

IT IS THE RESPONSIBILITY OF THE CONTRACTOR TO VERIFY ALL DIMENSIONS ON THE SITE AND REPORT ANY DISCREPANCIES OR VARIATIONS FROM THE SUPPLIED INFORMATION TO THE LANDSCAPE ARCHITECT WITH THE PROJECT. JDB ASSOCIATES LIMITED IS NOT RESPONSIBLE FOR THE ACCURACY OF SURVEY, ARCHITECTURAL, MECHANICAL, ENGINEERING OR ELECTRICAL INFORMATION SHOWN ON THE DRAWING. FOR FURTHER INFORMATION REFER TO APPROPRIATE SURVEY, ARCHITECTURAL, MECHANICAL, ENGINEERING OR ELECTRICAL DRAWINGS PRIOR TO PROCEEDING WITH ANY WORKS.

THIS DRAWING IS NOT TO BE SCALED.



BASE PLAN REVISED-JUNE 2022

Client info:

APPROVED


DATE

LANDSCAPE ARCHITECTS STAMP
STAMP AND ARCHITECTS SIGNATURE REQUIRED

JDB ASSOCIATES LTD.

Urban Designers
Landscape Architects
Arborists

274 Burton Ave., Suite 1201
Barrie, Ontario
L4N 5W4

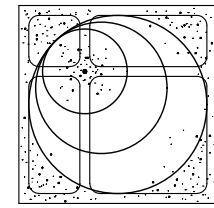


Fax: 705-722-5660
Tel: 705-722-6278

140 Mountain Rd.
Town of Collingwood

INDUSTRIAL BUILDING

TREE PRESERVATION DETAILS

SCALE: AS SHOWN	DATE:	DESIGNED BY: SJT	REVIEWED BY: NB
TOWN FILE No. D00921	OUR FILE REF. # 1-22	DRAWN BY: SJT	TP-2

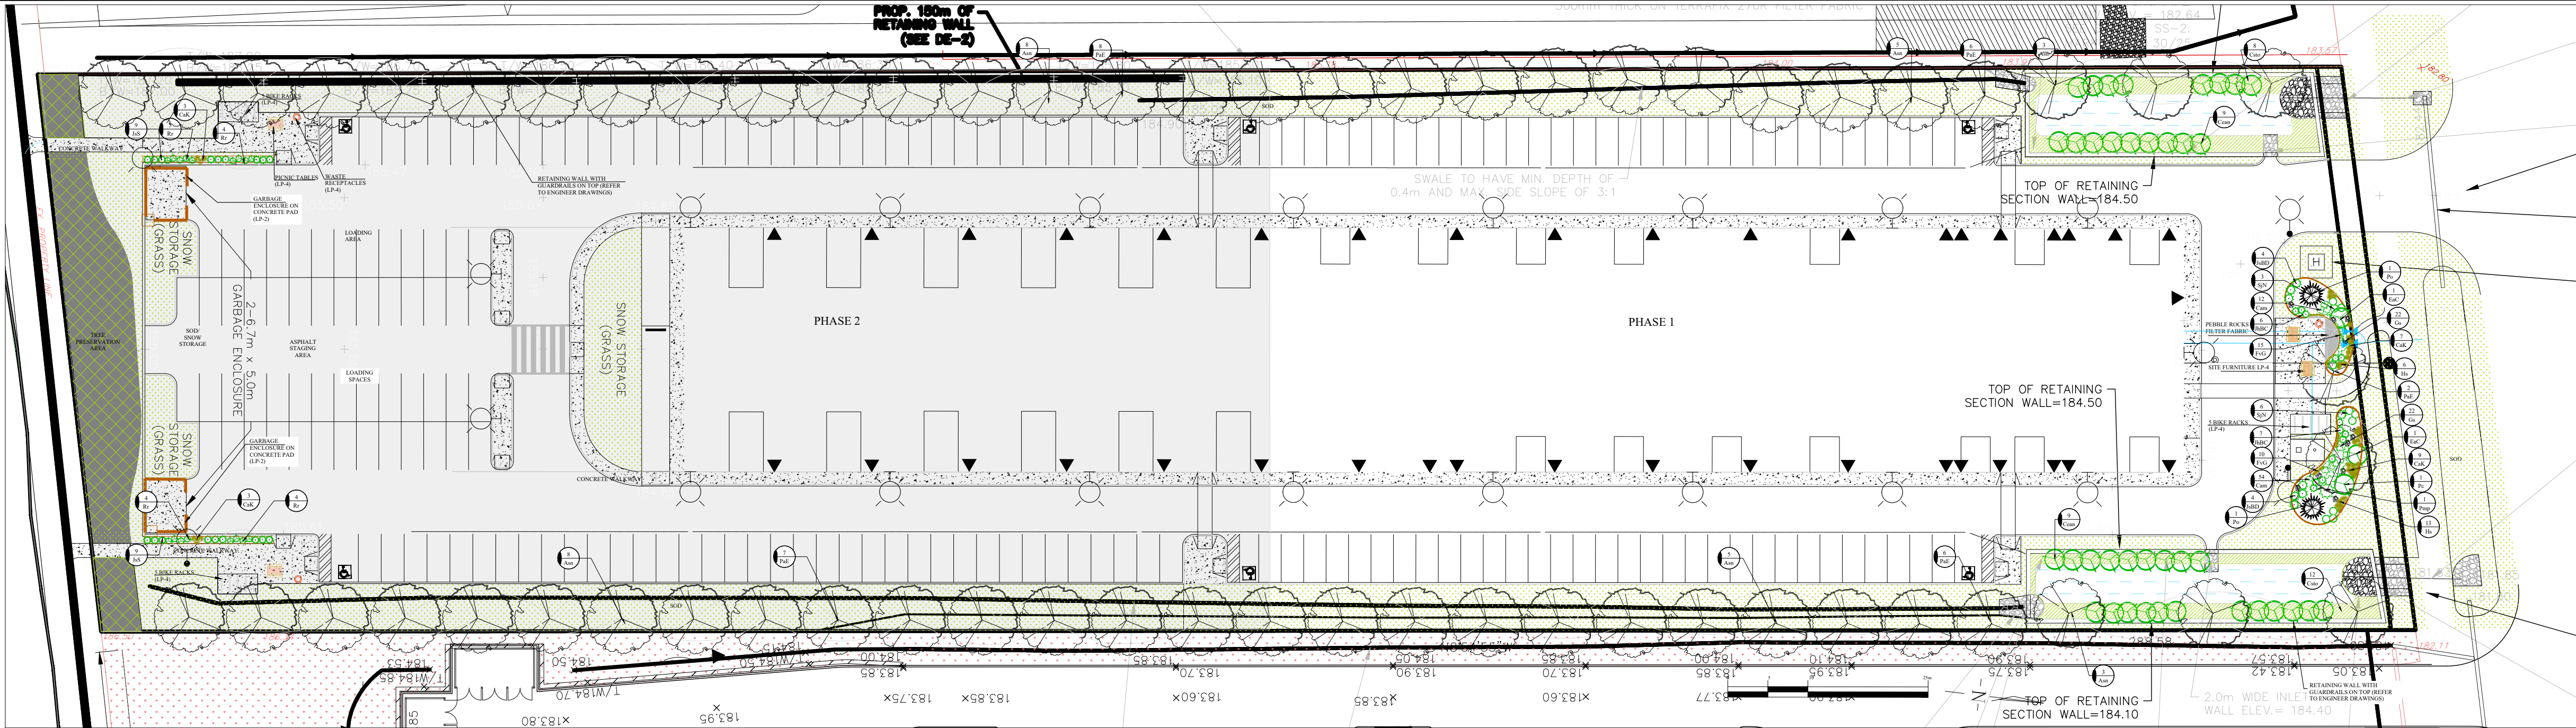

LANDSCAPE PLAN

CODE	QNTY	COMMON NAME	BOTANICAL NAME	SIZE	FORM	SPACING	DETAIL	NOTES
DECIDUOUS TREES								
Asn	16	SILVER MAPLE	Acer saccharinum	60 mm	W.B.	9.0 m o/c	1101	Full Form/ Fall pruning only
PaE	14	EXCLAMATION PLANE TREE	Platanus x acerifolia 'Exclamation'	60 mm	W.B.	9.0 m o/c	1101	Full Form/Acidic soil

CONIFEROUS TREES

Po	2	SERBIAN SPRUCE	Picea omorika	200cm	w.b.	As Per Drawing	1102	Full form / Do not cut leader
----	---	----------------	---------------	-------	------	----------------	------	-------------------------------

DECIDUOUS SHRUBS

Cean	18	NEW JERSEY TEA	Ceanothus americanus	60 cm	3 gal	1.8m o/c	1103	Full form / Container grown
Csto	20	RED OSIER DOGWOOD	Cornus stolonifera	60 cm	3 gal	2.0m o/c	1103	Full form / Container grown
EaC	2	DWARF WINGED BURNING BUSH	Euonymus alatus 'Compactus'	60 cm	3 gal.	1.60 m o/c	1103	Full form / Container grown
Pc	1	PURPLE LEAF SAND CHERRY	Prunus x cistena	60 cm	3 gal	0.90m o/c	1103	Full form / Container grown
SjN	9	NEON FLASH SPIRAEA	Spiraea japonica 'Neon Flash'	60 cm	3 gal	1.00m o/c	1103	Full form / Container grown

SPREADING EVERGREENS

JhBC	13	BLUE CHIP JUNIPER	Juniperus horizontalis 'Blue Chip'	40 cm	3 gal	2.0 m o/c	1103	Full form / Container grown
JsBD	8	BLUE DANUBE JUNIPER	Juiperus sabina 'Blue Danube'	40 cm	3 gal	1.25 m o/c	1103	Full form / Container grown
Pmp	1	MUGHO PINE	Pinus mugo var. pumilio	60cm	7 gal.	1.50 m o/c	1103	Full form / Container grown

PERENNIALS

Cam	66	HAREBELL	Campanula rotundifolia	1 gal	pot	0.45 m o/c	n/a	Full form / Container grown
Gs	44	BLOODY CRANESBILL	Geranium sanguineum	1 gal	pot	0.60 m o/c	n/a	Full form / Container grown

ORNAMENTAL GRASSES

CaK	16	KARL FOERSTER FEATHER REED GRASS	Calamagrostis arundinacea "Karl Foerster"	1 gal	pot	0.60 m o/c	n/a	Full form / Container grown
FvG	25	BLUE FESCUE	Festuca gluaca	1 gal	pot	0.30 m o/c	n/a	Full form / Container grown
Hs	19	SAPPHIRE FOUNTAIN BLUE OAT GRASS	Helictotrichon sempervirens 'Saphirsprudel'	1 gal	pot	0.60 m o/c	n/a	Full form / Container grown

PLANT LIST PHASE 1

REFER TO PLANTING NOTES AND DETAILS ON LP-3

CODE	QNTY	COMMON NAME	BOTANICAL NAME	SIZE	FORM	SPACING	DETAIL	NOTES
------	------	-------------	----------------	------	------	---------	--------	-------

DECIDUOUS TREES

Asn	16	SILVER MAPLE	Acer saccharinum	60 mm	W.B.	9.0 m o/c	1101	Full Form/ Fall pruning only
PaE	15	EXCLAMATION PLANE TREE	Platanus x acerifolia 'Exclamation'	60 mm	W.B.	9.0 m o/c	1101	Full Form/Acidic soil

DECIDUOUS SHRUBS

Rr	17	NEARLY WILD ROSE	Rosa rugosa 'Nearly Wild'	60 cm	3 gal	0.90m o/c	1103	Full form / Container grown
----	----	------------------	---------------------------	-------	-------	-----------	------	-----------------------------

UPRIGHT EVERGREENS

JsS	18	SKYROCKET JUNIPER	Juniperus scopulorum 'Skyrocket'	200cm	w.b.	0.90 m o/c	1103	Full form / Container grown
-----	----	-------------------	----------------------------------	-------	------	------------	------	-----------------------------

ORNAMENTAL GRASSES

CaK	6	KARL FOERSTER FEATHER REED GRASS	Calamagrostis arundinacea "Karl Foerster"	1 gal	pot	0.60 m o/c	n/a	Full form / Container grown
-----	---	----------------------------------	---	-------	-----	------------	-----	-----------------------------

PLANT LIST PHASE 2

REFER TO PLANTING NOTES AND DETAILS ON LP-3

DECIDUOUS TREES (LP-3)

CONIFERS (LP-3)

SHRUBS (LP-3)

PERENNIALS

ORNAMENTAL GRASSES

PROPERTY LINE (SITE PLAN)

MULCHED SHRUB PLANT BED.

WASTE RECEPTACLES (LP-4)

RETAINING WALL (Eng. plans).

LIGHTS (Lighting plan)

CONCRETE WALKWAY (LP-4)

PICNIC TABLES (LP-4)

SOD AREA

SWM POND NATIVE SEED MIX.

GENERAL LEGEND

GENERAL NOTES

CONTRACTOR IS RESPONSIBLE FOR ALL LOCATES INCLUDING ALL UNDERGROUND SERVICES PRIOR TO ANY EXCAVATION OR INSTALLATIONS. THE CONTRACTOR IS REQUIRED TO NOTIFY THE VARIOUS UTILITY COMPANIES 48 HOURS PRIOR TO THE COMMENCEMENT OF ANY WORK.

ANY ACCOMPANYING DOCUMENTATION RELATING TO THE LANDSCAPE PLAN AND/OR PRESERVATION PLAN SUCH AS TENDER DOCUMENTS AND CHANGE NOTICES ARE TO BE ENDORSED BY J.D.B. ASSOCIATES LIMITED PRIOR TO THE BEGINNING OF ANY SITE WORKS. IN THE EVENT THAT OF A DISCREPANCY THE DRAWING SHALL BE ASSUMED CORRECT.

IT IS THE RESPONSIBILITY OF THE PERSON OR PERSONS RESPONSIBLE FOR THE CONSTRUCTED WORKS TO NOTIFY THE LANDSCAPE ARCHITECT WHEN PREPARED FOR ANY REQUIRED INSPECTIONS AND SIGN OFFS.

SCHEDULED MEETINGS SHALL TAKE PLACE AT THE CLOSEST MUTUALLY CONVENIENT TIME.

No.	REVISION	DATE	APRVD.
1.	CLIENT REVIEW	November 25, 2020	SJT
2.	SITE PLAN REVISIONS	August 09, 2023	SJT
3.	REVISIONS AS PER TOWN COMMENTS	August 31, 2023	SJT
4.	SITE PLAN REVISIONS	April 9, 2024	SJT
5.	REVISIONS AS PER TOWN COMMENTS	September 4, 2024	SJT

ALL DRAWINGS AND SPECIFICATIONS ARE INSTRUMENTS OF SERVICE AND ARE THE PROPERTY OF JDB ASSOCIATES LIMITED. DRAWINGS ARE NOT TO BE MODIFIED AND/OR REPRODUCED WITHOUT THE WRITTEN CONSENT OF JDB ASSOCIATES LIMITED. REPRODUCTION OF DRAWINGS IN ANY FORM WITHOUT THE CONSENT OF JDB ASSOCIATES LIMITED VOIDS THE DRAWING AT WHICH TIME JDB ASSOCIATES LIMITED ACCEPTS NO LIABILITY FOR THE DRAWING CONTENT OR WORKS RESULTING FROM SAID REPRODUCTION.

DRAWINGS MAY BE REPRODUCED BY MUNICIPAL AND GOVERNMENT AGENCIES RESPONSIBLE FOR APPROVALS FOR THEIR OWN USE. JDB ASSOCIATES RESERVES THE RIGHT TO WITHDRAW ANY DRAWING(S) FROM GOVERNMENT OR MUNICIPAL AGENCIES WHETHER APPROVED OR NOT IN THE EVENT THAT ACCOUNTS ARE NOT SETTLED OR REMAIN OUTSTANDING.

IT IS THE RESPONSIBILITY OF THE CONTRACTOR TO VERIFY ALL DIMENSIONS ON THE SITE AND REPORT ANY DISCREPANCIES OR VARIATIONS FROM THE SUPPLIED INFORMATION TO THE LANDSCAPE ARCHITECT WITH THE PROJECT. JDB ASSOCIATES LIMITED IS NOT RESPONSIBLE FOR THE ACCURACY OF SURVEY, ARCHITECTURAL, MECHANICAL, ENGINEERING OR ELECTRICAL INFORMATION SHOWN ON THE DRAWING. FOR FURTHER INFORMATION REFER TO APPROPRIATE SURVEY, ARCHITECTURAL, MECHANICAL, ENGINEERING OR ELECTRICAL DRAWINGS PRIOR TO PROCEEDING WITH ANY WORKS.

THIS DRAWING IS NOT TO BE SCALED.

BASE PLAN REVISED-JUNE 2022

Client info:

APPROVED

DATE

LANDSCAPE ARCHITECTS STAMP
STAMP AND SIGNATURE TO BE REPRODUCED

JDB ASSOCIATES LTD.

Urban Designers
Landscape Architects
Arborists


274 Burton Ave., Suite 1201
Barrie, Ontario
L4N 5W4

Fax: 705-722-5660
Tel: 705-722-6278


140 Mountain Rd.
Town of Collingwood
INDUSTRIAL BUILDING

LANDSCAPE PLAN

SCALE: AS SHOWN	DATE:	DESIGNED BY: SJT	REVIEWED BY: NB
TOWN FILE No. D00921	OUR FILE REF. # 1-22	DRAWN BY: SJT	LP-1

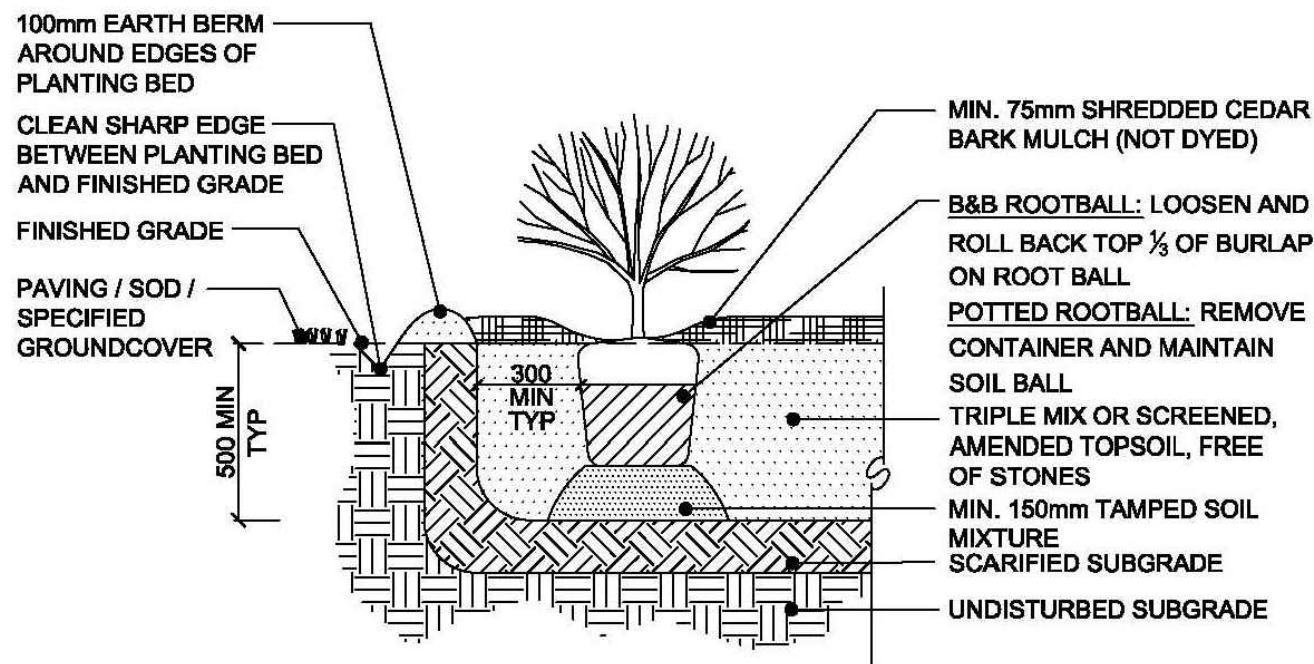

TYPICAL SHRUB PLANTING

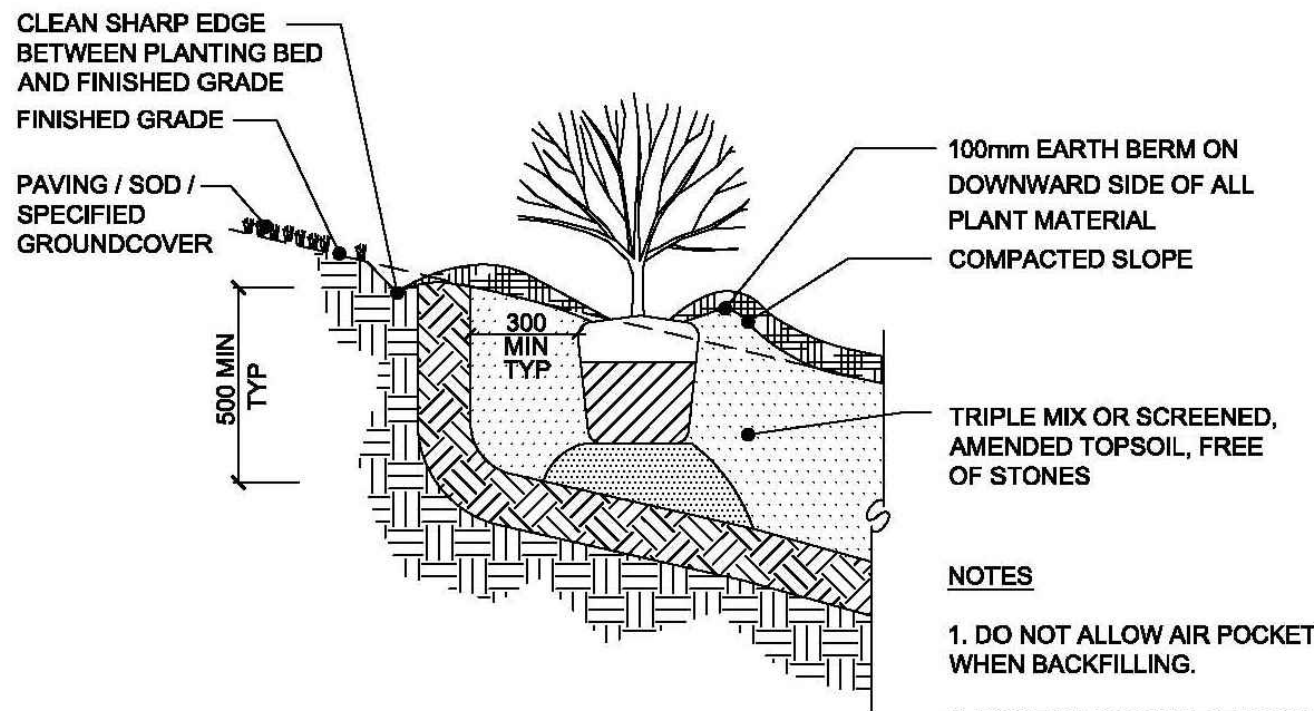


PLANTING ON 3:1 SLOPE DETAIL

NO.	REVISION	APRD	DATE
1	PLANTING METHODOLOGY	EN	JUL/04
2	PLANTING METHODOLOGY	DW	JUN/07

TOWN OF COLLINGWOOD		APRD: DW	DATE: JAN/03
		DRAWN: AB	SCALE: NTS
SHRUB PLANTING		STD. No.	1103

SHRUB PLANTING DETAIL (Typ.)

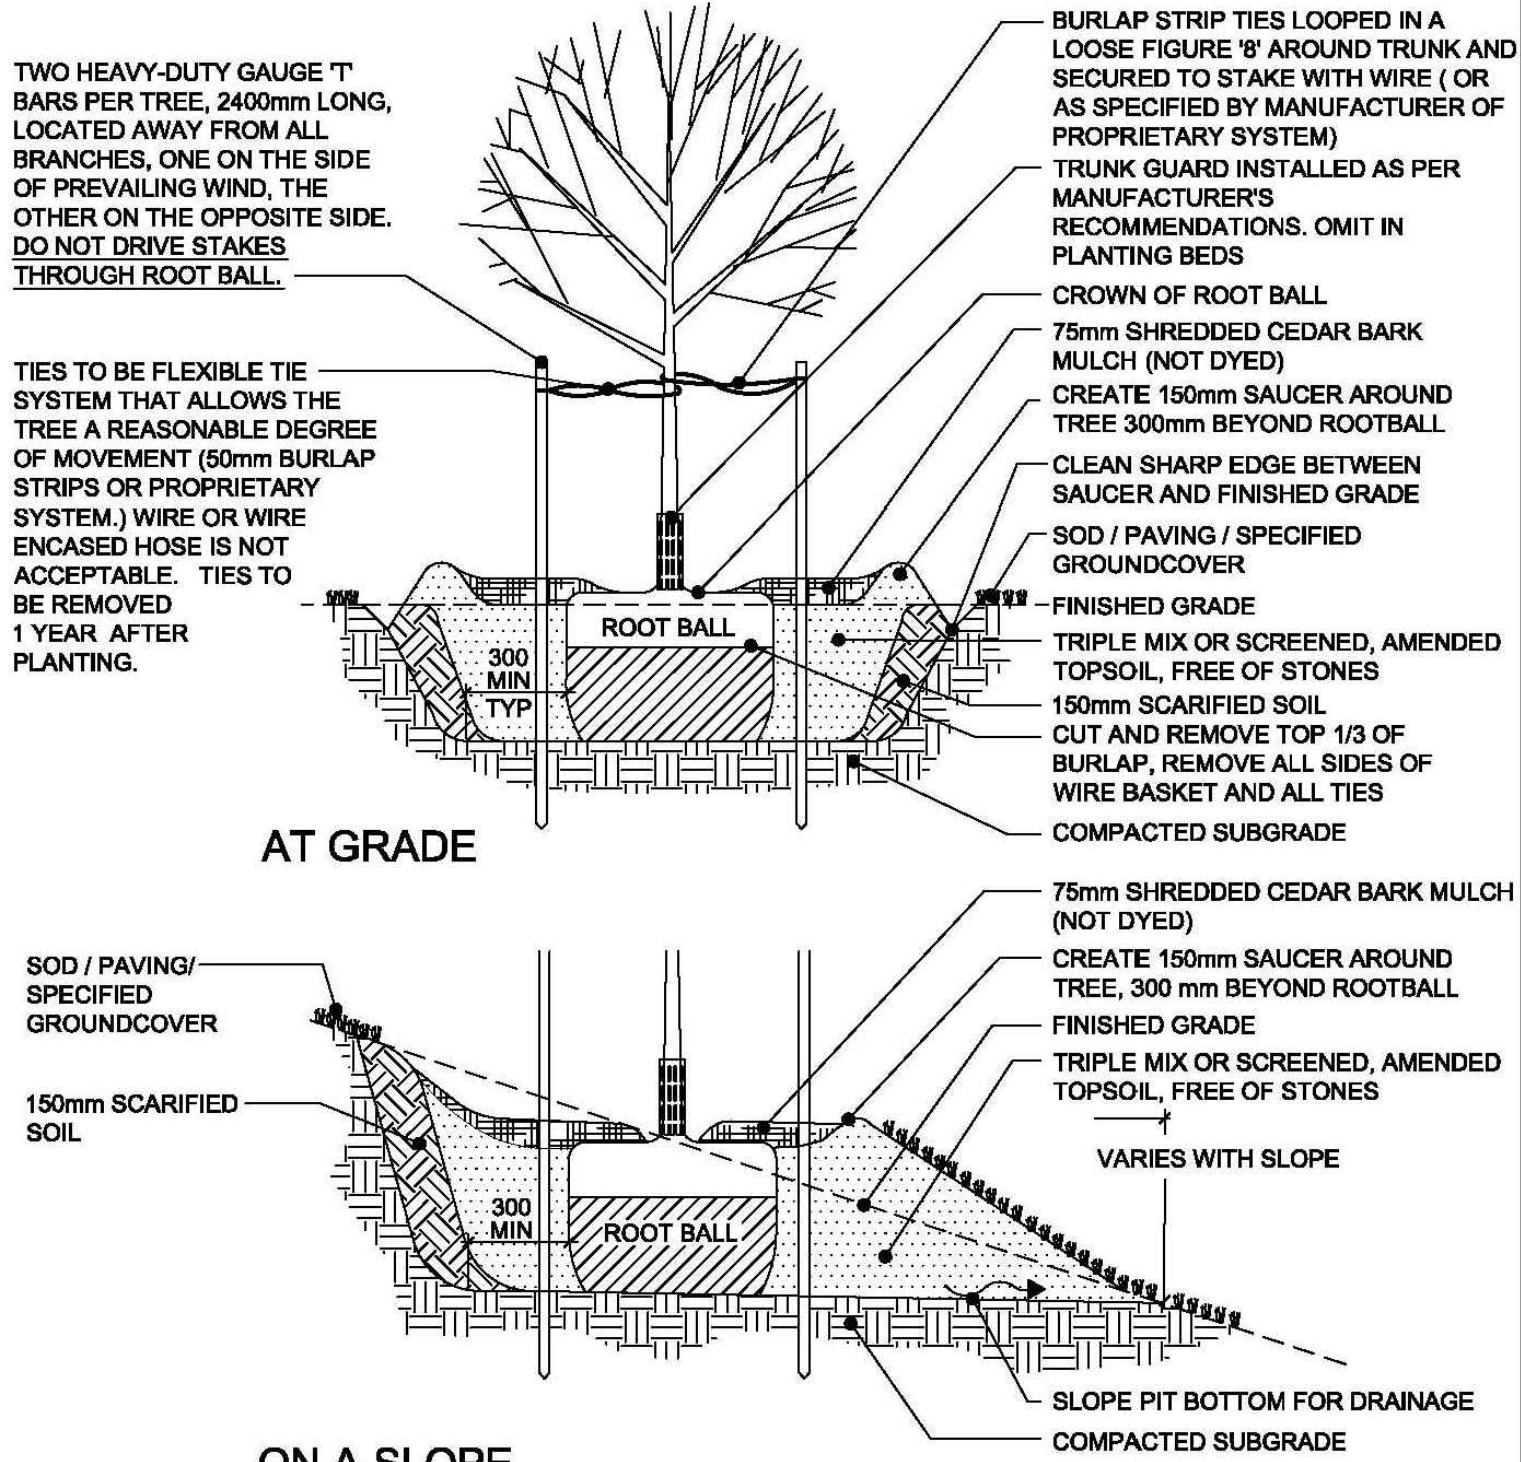


- NOTES
- DO NOT ALLOW AIR POCKETS WHEN BACKFILLING.
 - POSITION CROWN OF ROOT BALL 50mm ABOVE FINISHED GRADE TO ALLOW FOR SETTLING.
 - DO CORRECTIVE PRUNING TO RETAIN NATURAL FORM OF TREE.
 - FOR TREES PLANTED WITHIN PLANTING OR SHRUB BEDS, DELETE SAUCER AROUND BASE OF TREE.
 - NO TREE PITTS SHALL BE LEFT OPEN OVERNIGHT.
 - ALL DIMENSIONS ARE IN MILLIMETRES.

NO.	REVISION	APRD	DATE
1	PLANTING METHODOLOGY	EN	JUL/04
2	PLANTING METHODOLOGY	DW	JUN/07

TOWN OF COLLINGWOOD		APRD: DW	DATE: JAN/03
		DRAWN: AB	SCALE: NTS
DECIDUOUS TREE PLANTING		STD. No.	1101

DECIDUOUS TREE PLANTING DETAIL (Typ.)

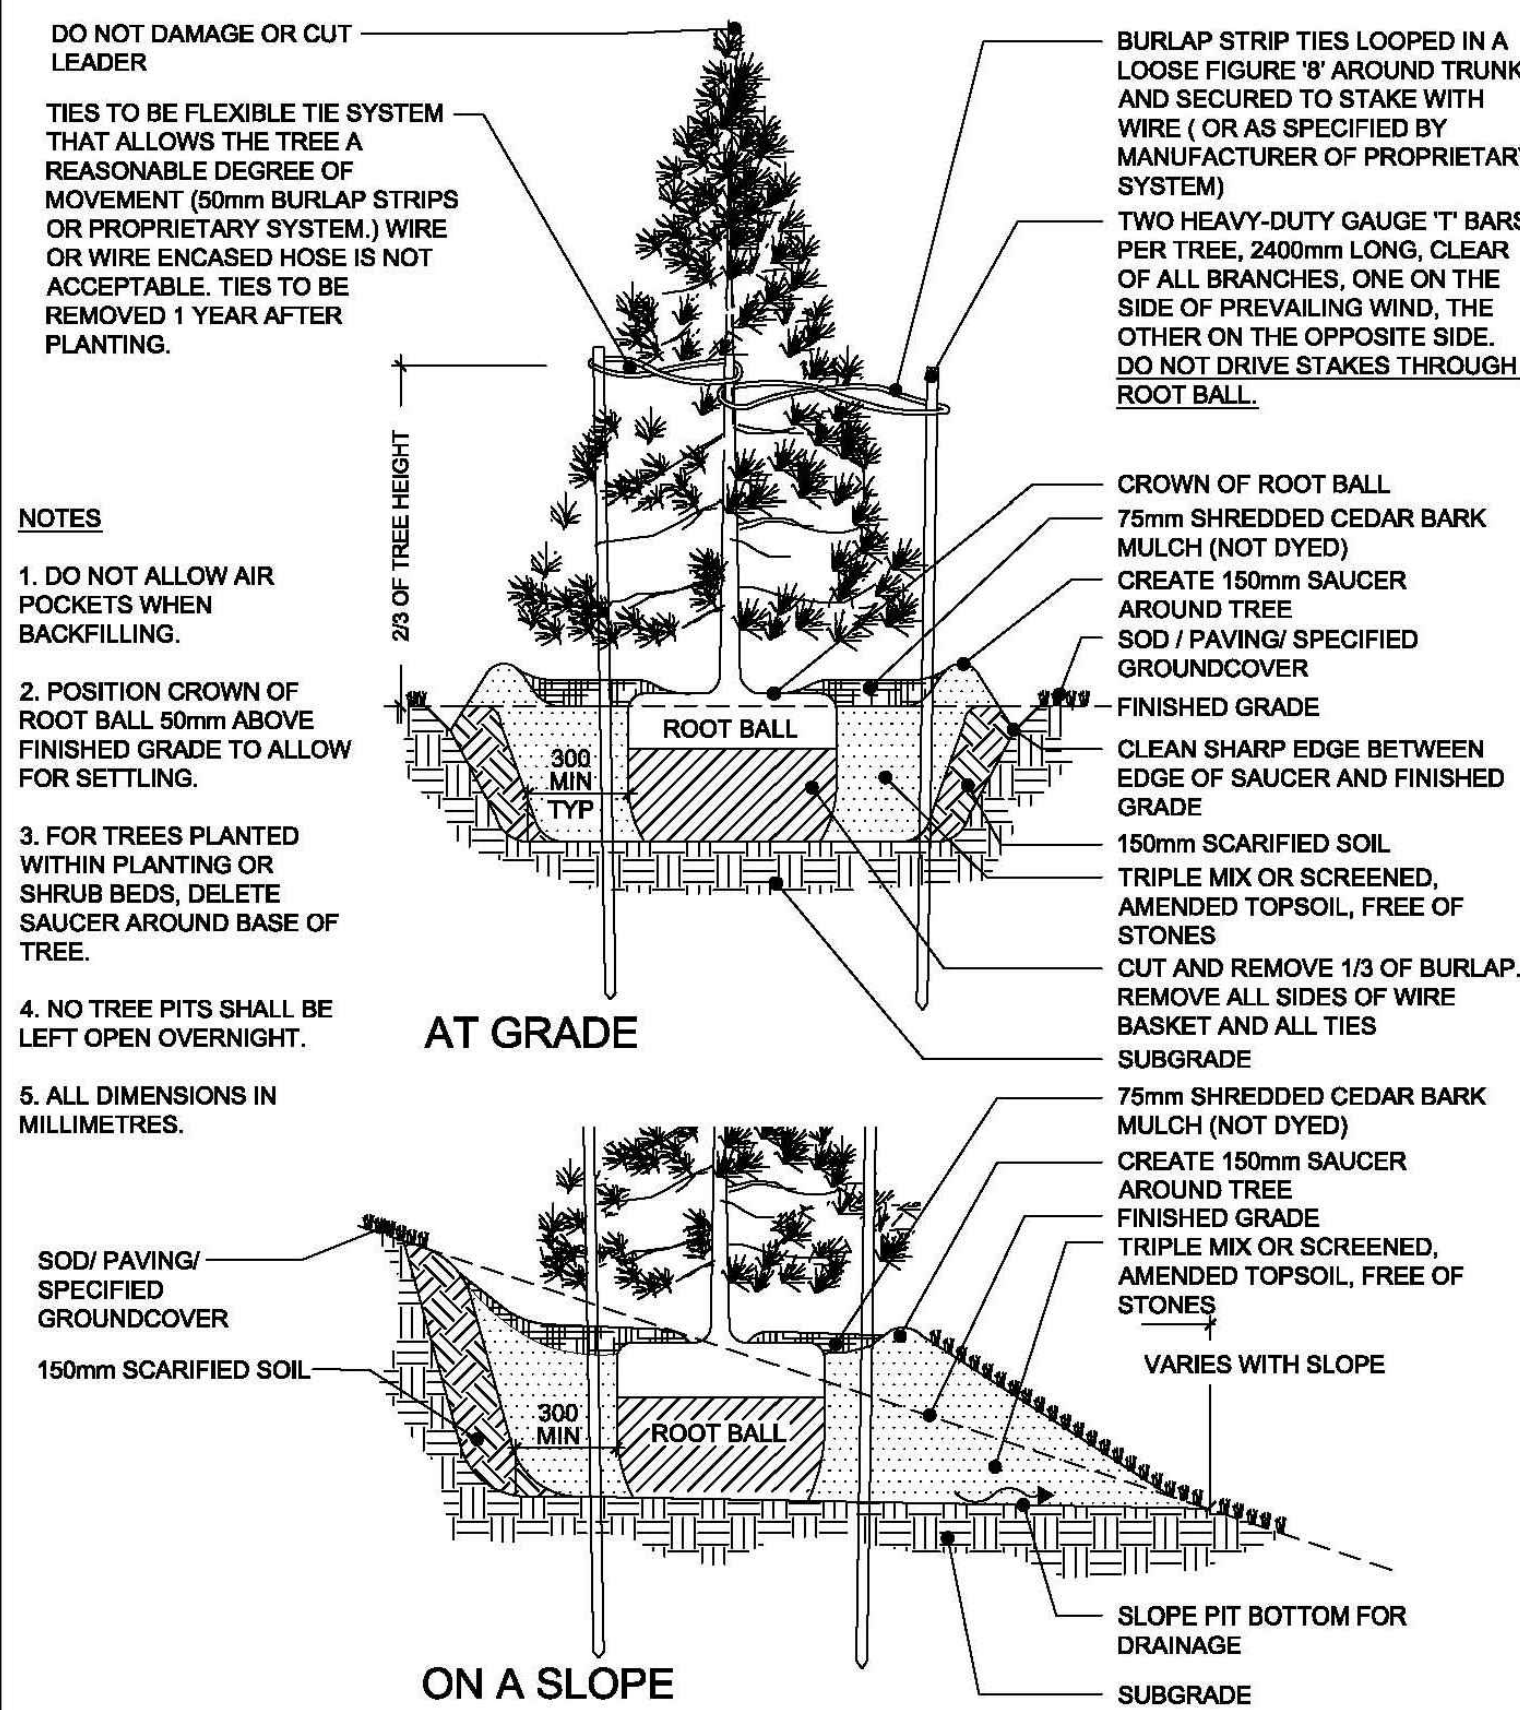


- NOTES
- DO NOT ALLOW AIR POCKETS WHEN BACKFILLING.
 - POSITION CROWN OF ROOT BALL 50mm ABOVE FINISHED GRADE TO ALLOW FOR SETTLING.
 - FOR TREES PLANTED WITHIN PLANTING OR SHRUB BEDS, DELETE SAUCER AROUND BASE OF TREE.
 - NO TREE PITTS SHALL BE LEFT OPEN OVERNIGHT.
 - ALL DIMENSIONS IN MILLIMETRES.

NO.	REVISION	APRD	DATE
1	PLANTING METHODOLOGY	EN	JUL/04
2	PLANTING METHODOLOGY	DW	JUN/07

TOWN OF COLLINGWOOD		APRD: DW	DATE: JAN/03
		DRAWN: AB	SCALE: NTS
CONIFEROUS TREE PLANTING		STD. No.	1102

CONIFEROUS TREE PLANTING DETAIL (Typ.)

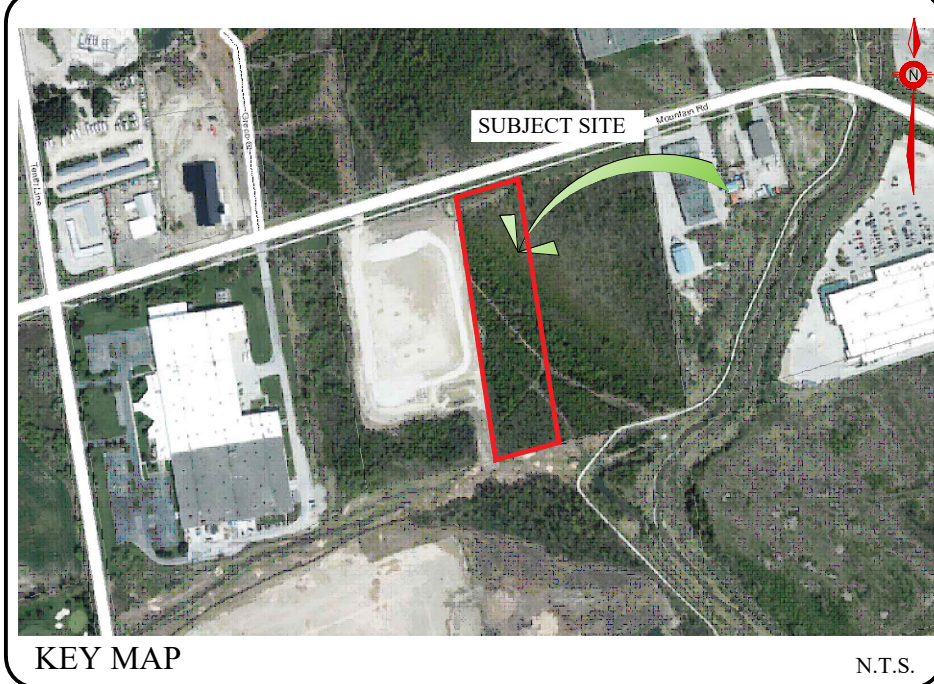

GENERAL NOTES

CONTRACTOR IS RESPONSIBLE FOR ALL LOCATES INCLUDING ALL UNDERGROUND SERVICES PRIOR TO ANY EXCAVATION OR INSTALLATIONS. THE CONTRACTOR IS REQUIRED TO NOTIFY THE VARIOUS UTILITY COMPANIES 48 HOURS PRIOR TO THE COMMENCEMENT OF ANY WORK.

ANY ACCOMPANYING DOCUMENTATION RELATING TO THE LANDSCAPE PLAN AND/OR PRESERVATION PLAN SUCH AS TENDER DOCUMENTS AND CHANGE NOTICES ARE TO BE ENDORSED BY J.D.B. ASSOCIATES LIMITED PRIOR TO THE BEGINNING OF ANY SITE WORKS. IN THE EVENT THAT OF A DISCREPANCY THE DRAWING SHALL BE ASSUMED CORRECT.

IT IS THE RESPONSIBILITY OF THE PERSON OR PERSONS RESPONSIBLE FOR THE CONSTRUCTED WORKS TO NOTIFY THE LANDSCAPE ARCHITECT WHEN PREPARED FOR ANY REQUIRED INSPECTIONS AND SIGN OFFS.

SCHEDULED MEETINGS SHALL TAKE PLACE AT THE CLOSEST MUTUALLY CONVENIENT TIME.

NO.	REVISION	DATE	APRD.
1.	CLIENT REVIEW	November 25, 2020	ST
2.	SITE PLAN REVISIONS	August 09, 2023	ST
3.	REVISIONS AS PER TOWN COMMENTS	August 31, 2023	ST
4.	SITE PLAN REVISIONS	April 9, 2024	ST
5.	REVISIONS AS PER TOWN COMMENTS	September 4, 2024	ST

ALL DRAWINGS AND SPECIFICATIONS ARE INSTRUMENTS OF SERVICE AND ARE THE PROPERTY OF JDB ASSOCIATES LIMITED. DRAWINGS ARE NOT TO BE MODIFIED AND/OR REPRODUCED WITHOUT THE WRITTEN CONSENT OF JDB ASSOCIATES LIMITED. REPRODUCTION OF DRAWINGS IN ANY FORM WITHOUT THE CONSENT OF JDB ASSOCIATES LIMITED VOIDS THE DRAWING AT WHICH TIME JDB ASSOCIATES LIMITED ACCEPTS NO LIABILITY FOR THE DRAWING CONTENT OR WORKS RESULTING FROM SAID REPRODUCTION. DRAWINGS MAY BE REPRODUCED BY MUNICIPAL AND GOVERNMENT AGENCIES RESPONSIBLE FOR APPROVALS FOR THEIR OWN USE. JDB ASSOCIATES RESERVES THE RIGHT TO WITHDRAW ANY DRAWING(S) FROM GOVERNMENT OR MUNICIPAL AGENCIES WHETHER APPROVED OR NOT IN THE EVENT THAT ACCOUNTS ARE NOT SETTLED OR REMAIN OUTSTANDING.

IT IS THE RESPONSIBILITY OF THE CONTRACTOR TO VERIFY ALL DIMENSIONS ON THE SITE AND REPORT ANY DISCREPANCIES OR VARIATIONS FROM THE SUPPLIED INFORMATION TO THE LANDSCAPE ARCHITECT WITH THE PROJECT. JDB ASSOCIATES LIMITED IS NOT RESPONSIBLE FOR THE ACCURACY OF SURVEY, ARCHITECTURAL, MECHANICAL, ENGINEERING OR ELECTRICAL INFORMATION SHOWN ON THE DRAWING. FOR FURTHER INFORMATION REFER TO APPROPRIATE SURVEY, ARCHITECTURAL, MECHANICAL, ENGINEERING OR ELECTRICAL DRAWINGS PRIOR TO PROCEEDING WITH ANY WORKS.

THIS DRAWING IS NOT TO BE SCALED.



Client info:

APPROVED


LANDSCAPE ARCHITECTS STAMP
STAMP AND SIGNATURE VOID IF REPRODUCED

JDB ASSOCIATES LTD.
Urban Designers
Landscape Architects
Arborists
274 Burton Ave., Suite 1201
Barrie, Ontario
L4N 5W4
Fax: 705-722-5660
Tel: 705-722-6278

140 Mountain Rd.
Town of Collingwood
INDUSTRIAL BUILDING

PLANTING DETAILS

SCALE: 1/25	DATE:	DESIGNED BY: ST	REVIEWED BY: NB
TOWN FILE No. D00921	OUR FILE REF. # 1-22	DRAWN BY: ST	LP-3

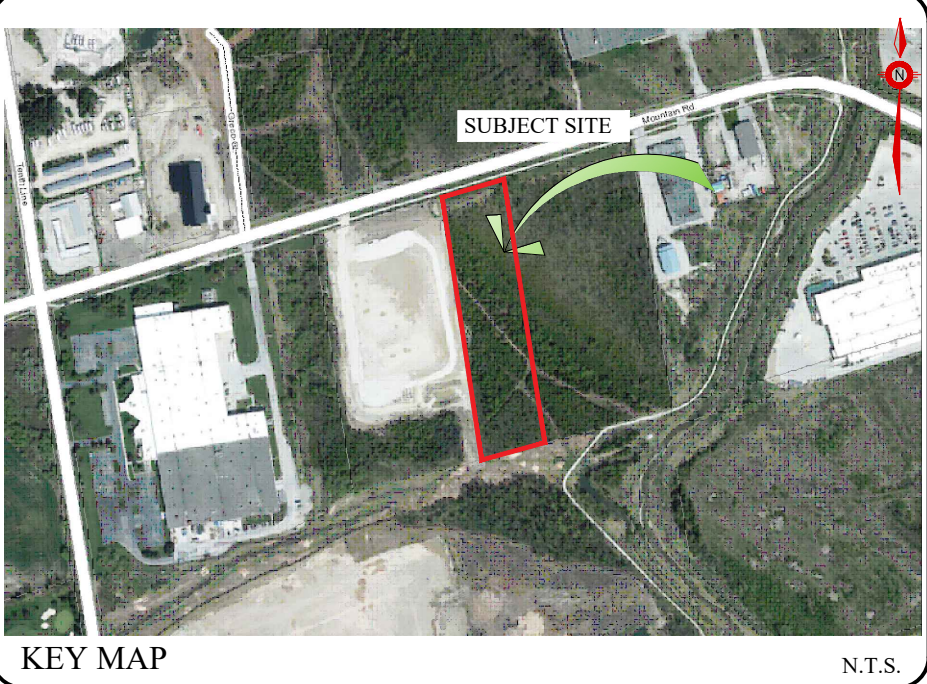

GENERAL NOTES

CONTRACTOR IS RESPONSIBLE FOR ALL LOCATES INCLUDING ALL UNDERGROUND SERVICES PRIOR TO ANY EXCAVATION OR INSTALLATIONS. THE CONTRACTOR IS REQUIRED TO NOTIFY THE VARIOUS UTILITY COMPANIES 48 HOURS PRIOR TO THE COMMENCEMENT OF ANY WORK.

ANY ACCOMPANYING DOCUMENTATION RELATING TO THE LANDSCAPE PLAN AND/OR PRESERVATION PLAN SUCH AS TENDER DOCUMENTS AND CHANGE NOTICES ARE TO BE ENDORSED BY J.D.B. ASSOCIATES LIMITED PRIOR TO THE BEGINNING OF ANY SITE WORKS. IN THE EVENT THAT OF A DISCREPANCY THE DRAWING SHALL BE ASSUMED CORRECT.

IT IS THE RESPONSIBILITY OF THE PERSON OR PERSONS RESPONSIBLE FOR THE CONSTRUCTED WORKS TO NOTIFY THE LANDSCAPE ARCHITECT WHEN PREPARED FOR ANY REQUIRED INSPECTIONS AND SIGN OFFS.

SCHEDULED MEETINGS SHALL TAKE PLACE AT THE CLOSEST MUTUALLY CONVENIENT TIME.

No.	REVISION	DATE	APRVD.
1.	CLIENT REVIEW	November 25, 2020	ST
2.	SITE PLAN REVISIONS	August 09, 2023	ST
3.	REVISIONS AS PER TOWN COMMENTS	August 31, 2023	ST
4.	SITE PLAN REVISIONS	April 9, 2024	ST
5.	REVISIONS AS PER TOWN COMMENTS	September 4, 2024	ST

ALL DRAWINGS AND SPECIFICATIONS ARE INSTRUMENTS OF SERVICE AND ARE THE PROPERTY OF JDB ASSOCIATES LIMITED. DRAWINGS ARE NOT TO BE MODIFIED AND/OR REPRODUCED WITHOUT THE WRITTEN CONSENT OF JDB ASSOCIATES LIMITED. REPRODUCTION OF DRAWINGS IN ANY FORM WITHOUT THE CONSENT OF JDB ASSOCIATES LIMITED VOIDS THE DRAWING AT WHICH TIME JDB ASSOCIATES LIMITED ACCEPTS NO LIABILITY FOR THE DRAWING CONTENT OR WORKS RESULTING FROM SAID REPRODUCTION. DRAWINGS MAY BE REPRODUCED BY MUNICIPAL AND GOVERNMENT AGENCIES RESPONSIBLE FOR APPROVALS FOR THEIR OWN USE. JDB ASSOCIATES RESERVES THE RIGHT TO WITHDRAW ANY DRAWING(S) FROM GOVERNMENT OR MUNICIPAL AGENCIES WHETHER APPROVED OR NOT IN THE EVENT THAT ACCOUNTS ARE NOT SETTLED OR REMAIN OUTSTANDING.

IT IS THE RESPONSIBILITY OF THE CONTRACTOR TO VERIFY ALL DIMENSIONS ON THE SITE AND REPORT ANY DISCREPANCIES OR VARIATIONS FROM THE SUPPLIED INFORMATION TO THE LANDSCAPE ARCHITECT WITH THE PROJECT. JDB ASSOCIATES LIMITED IS NOT RESPONSIBLE FOR THE ACCURACY OF SURVEY, ARCHITECTURAL, MECHANICAL, ENGINEERING OR ELECTRICAL INFORMATION SHOWN ON THE DRAWING. FOR FURTHER INFORMATION REFER TO APPROPRIATE SURVEY, ARCHITECTURAL, MECHANICAL, ENGINEERING OR ELECTRICAL DRAWINGS PRIOR TO PROCEEDING WITH ANY WORKS.

THIS DRAWING IS NOT TO BE SCALED.



BASE PLAN REVISED: JUNE 2022

Client info:

APPROVED	LANDSCAPE ARCHITECTS STAMP (SEAL AND SIGNATURE VOID IF REPRODUCED)
DATE	

JDB ASSOCIATES LTD.
*Urban Designers
Landscape Architects
Arborists*
274 Burton Ave., Suite 1201
Barrie, Ontario
L4N 5W4


Fax: 705-722-5660
Tel: 705-722-6278

140 Mountain Rd.
Town of Collingwood

INDUSTRIAL BUILDING

SITE FURNITURE AND PAVING DETAILS

SCALE: N.T.S.	DATE:	DESIGNED BY: ST	REVIEWED BY: NB
TOWN FILE No. D00921	OUR FILE REF. # 1-22	DRAWN BY: ST	LP-4

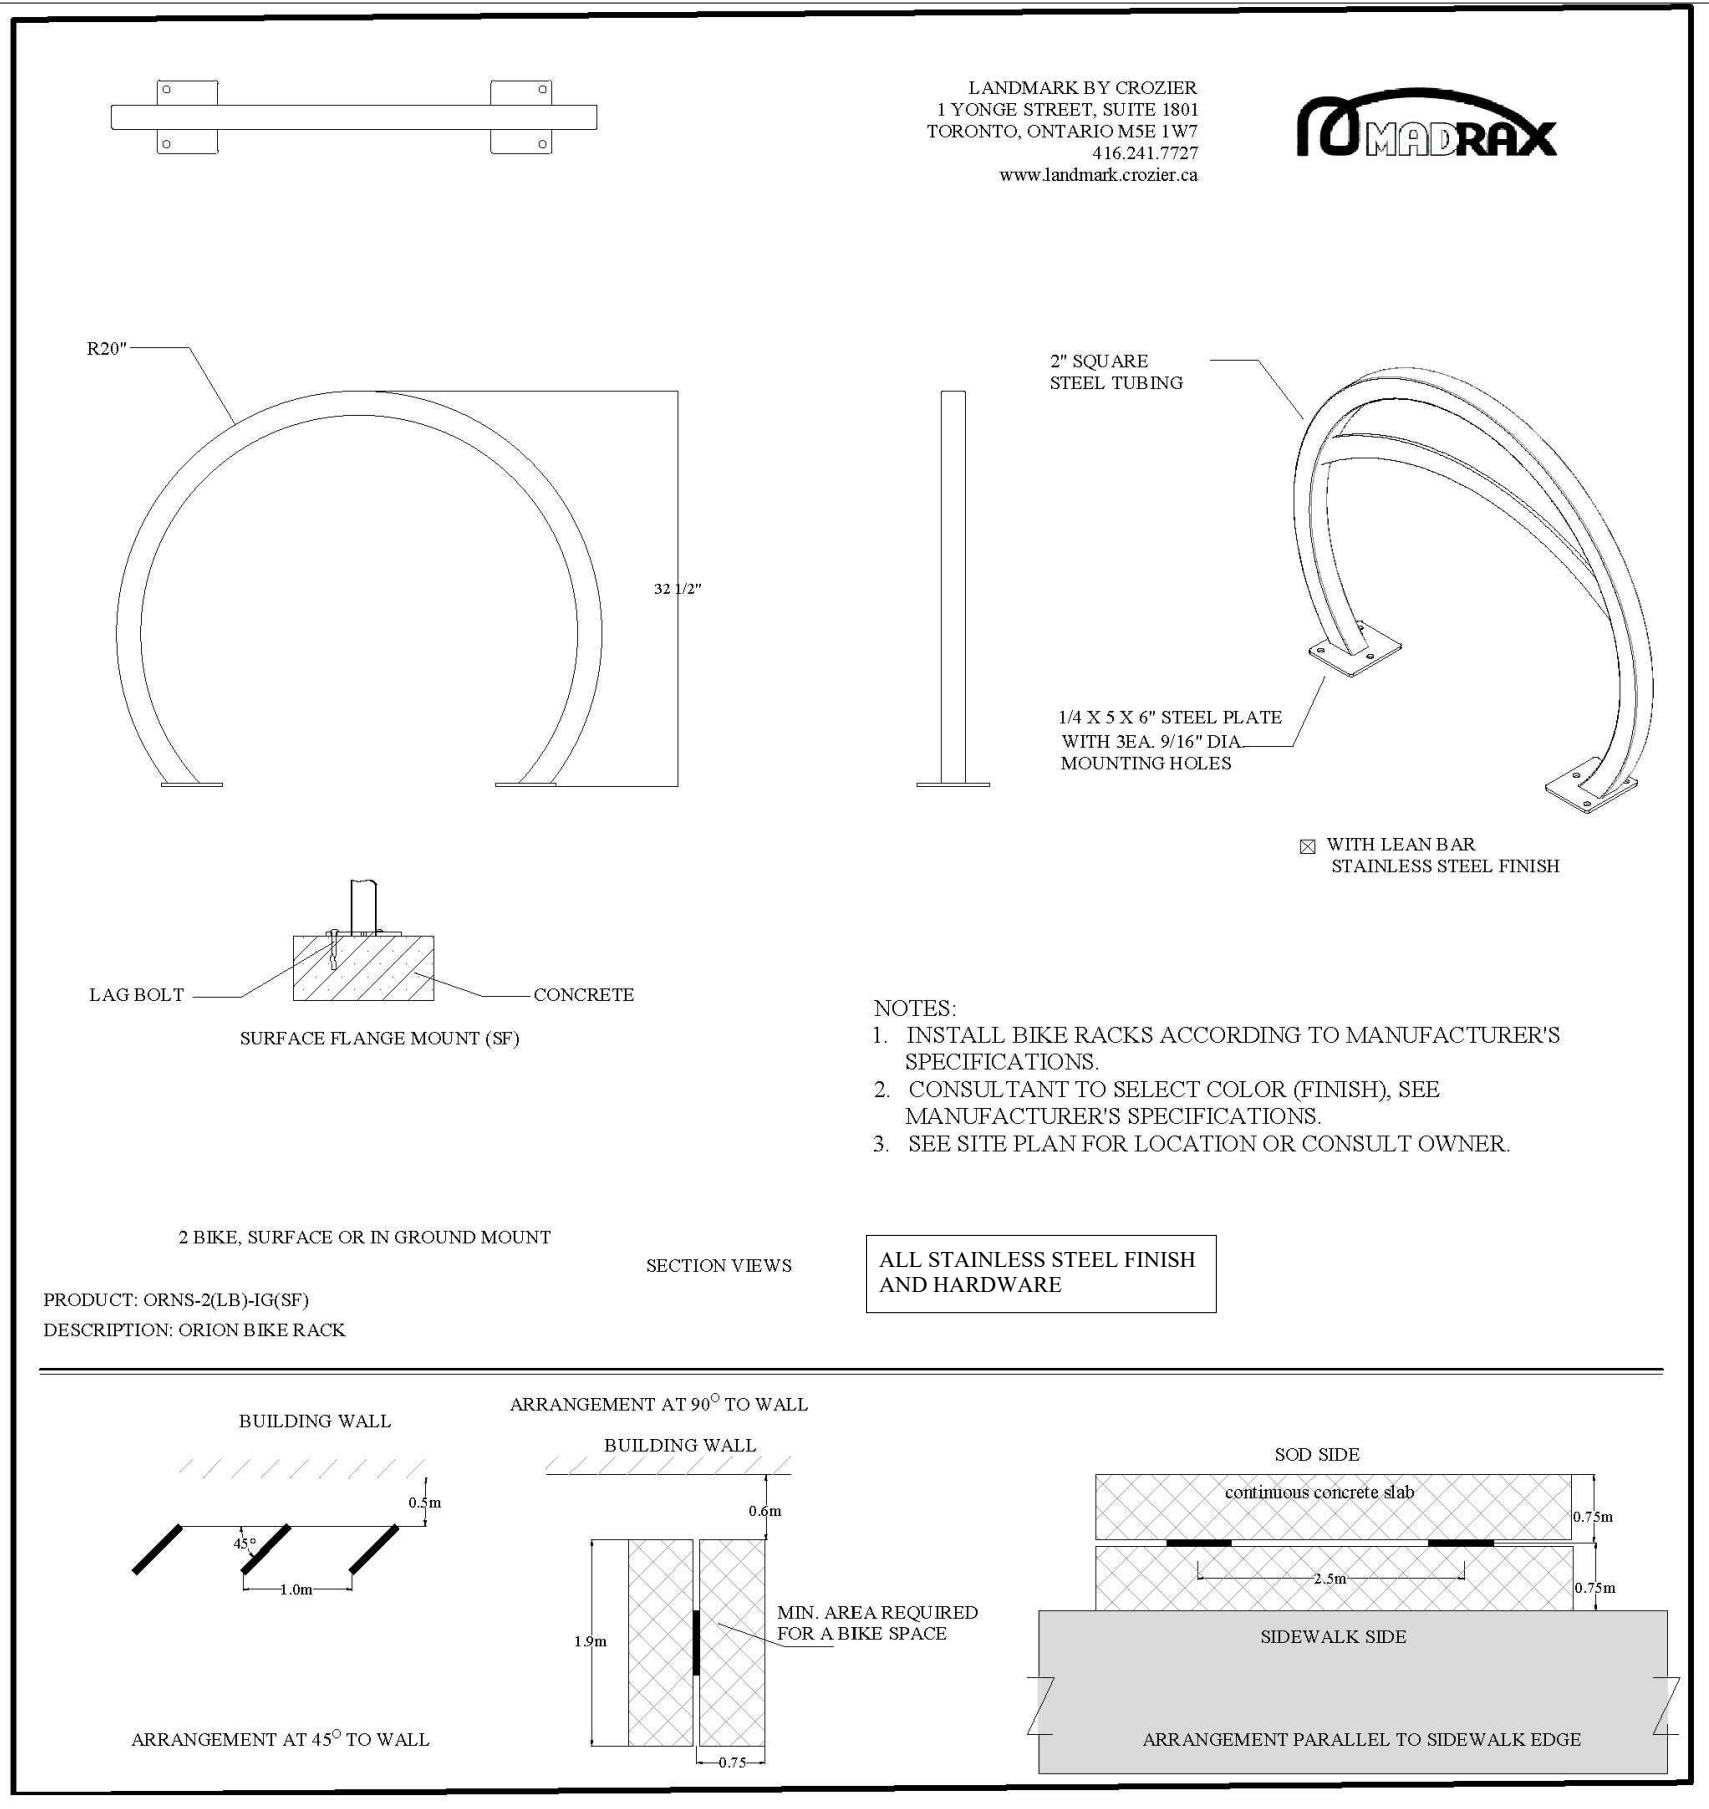

BIKE RACK DETAIL (Typ.)



ACCESSIBLE PICNIC BENCH DETAIL (Typ.)

Courtyard Trash Can - 32 Gallon

Elegant trash can for patios, gardens or walkways. Recommended for hotels and shopping centers.

- Glossy, premium powder-coated finish is weather resistant and long lasting.
- Durable, heavy-duty steel bar construction.
- Reusable rigid plastic liner. Easy to empty and clean.
- Flat metal lid with 13" opening.
- Coordinating *Courtyard Furniture* available.
- Recommended trash liners: Use [S-5105](#) or [S-2053](#).

WASTE RECEPTACLE- ULINE.ca, MODEL H-3022