


LEGEND

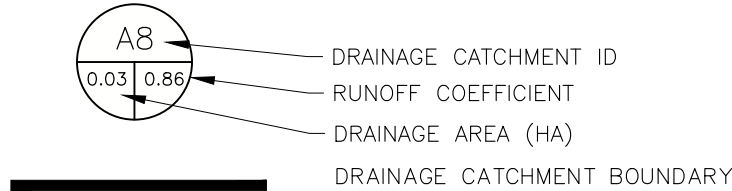

10045 HIGHWAY 26

STORM DRAINAGE PLAN

DWG. No.
STM-1

SCALE: 1:750 DRAWN: AO DATE: FEB/25 JOB NO. 122093