



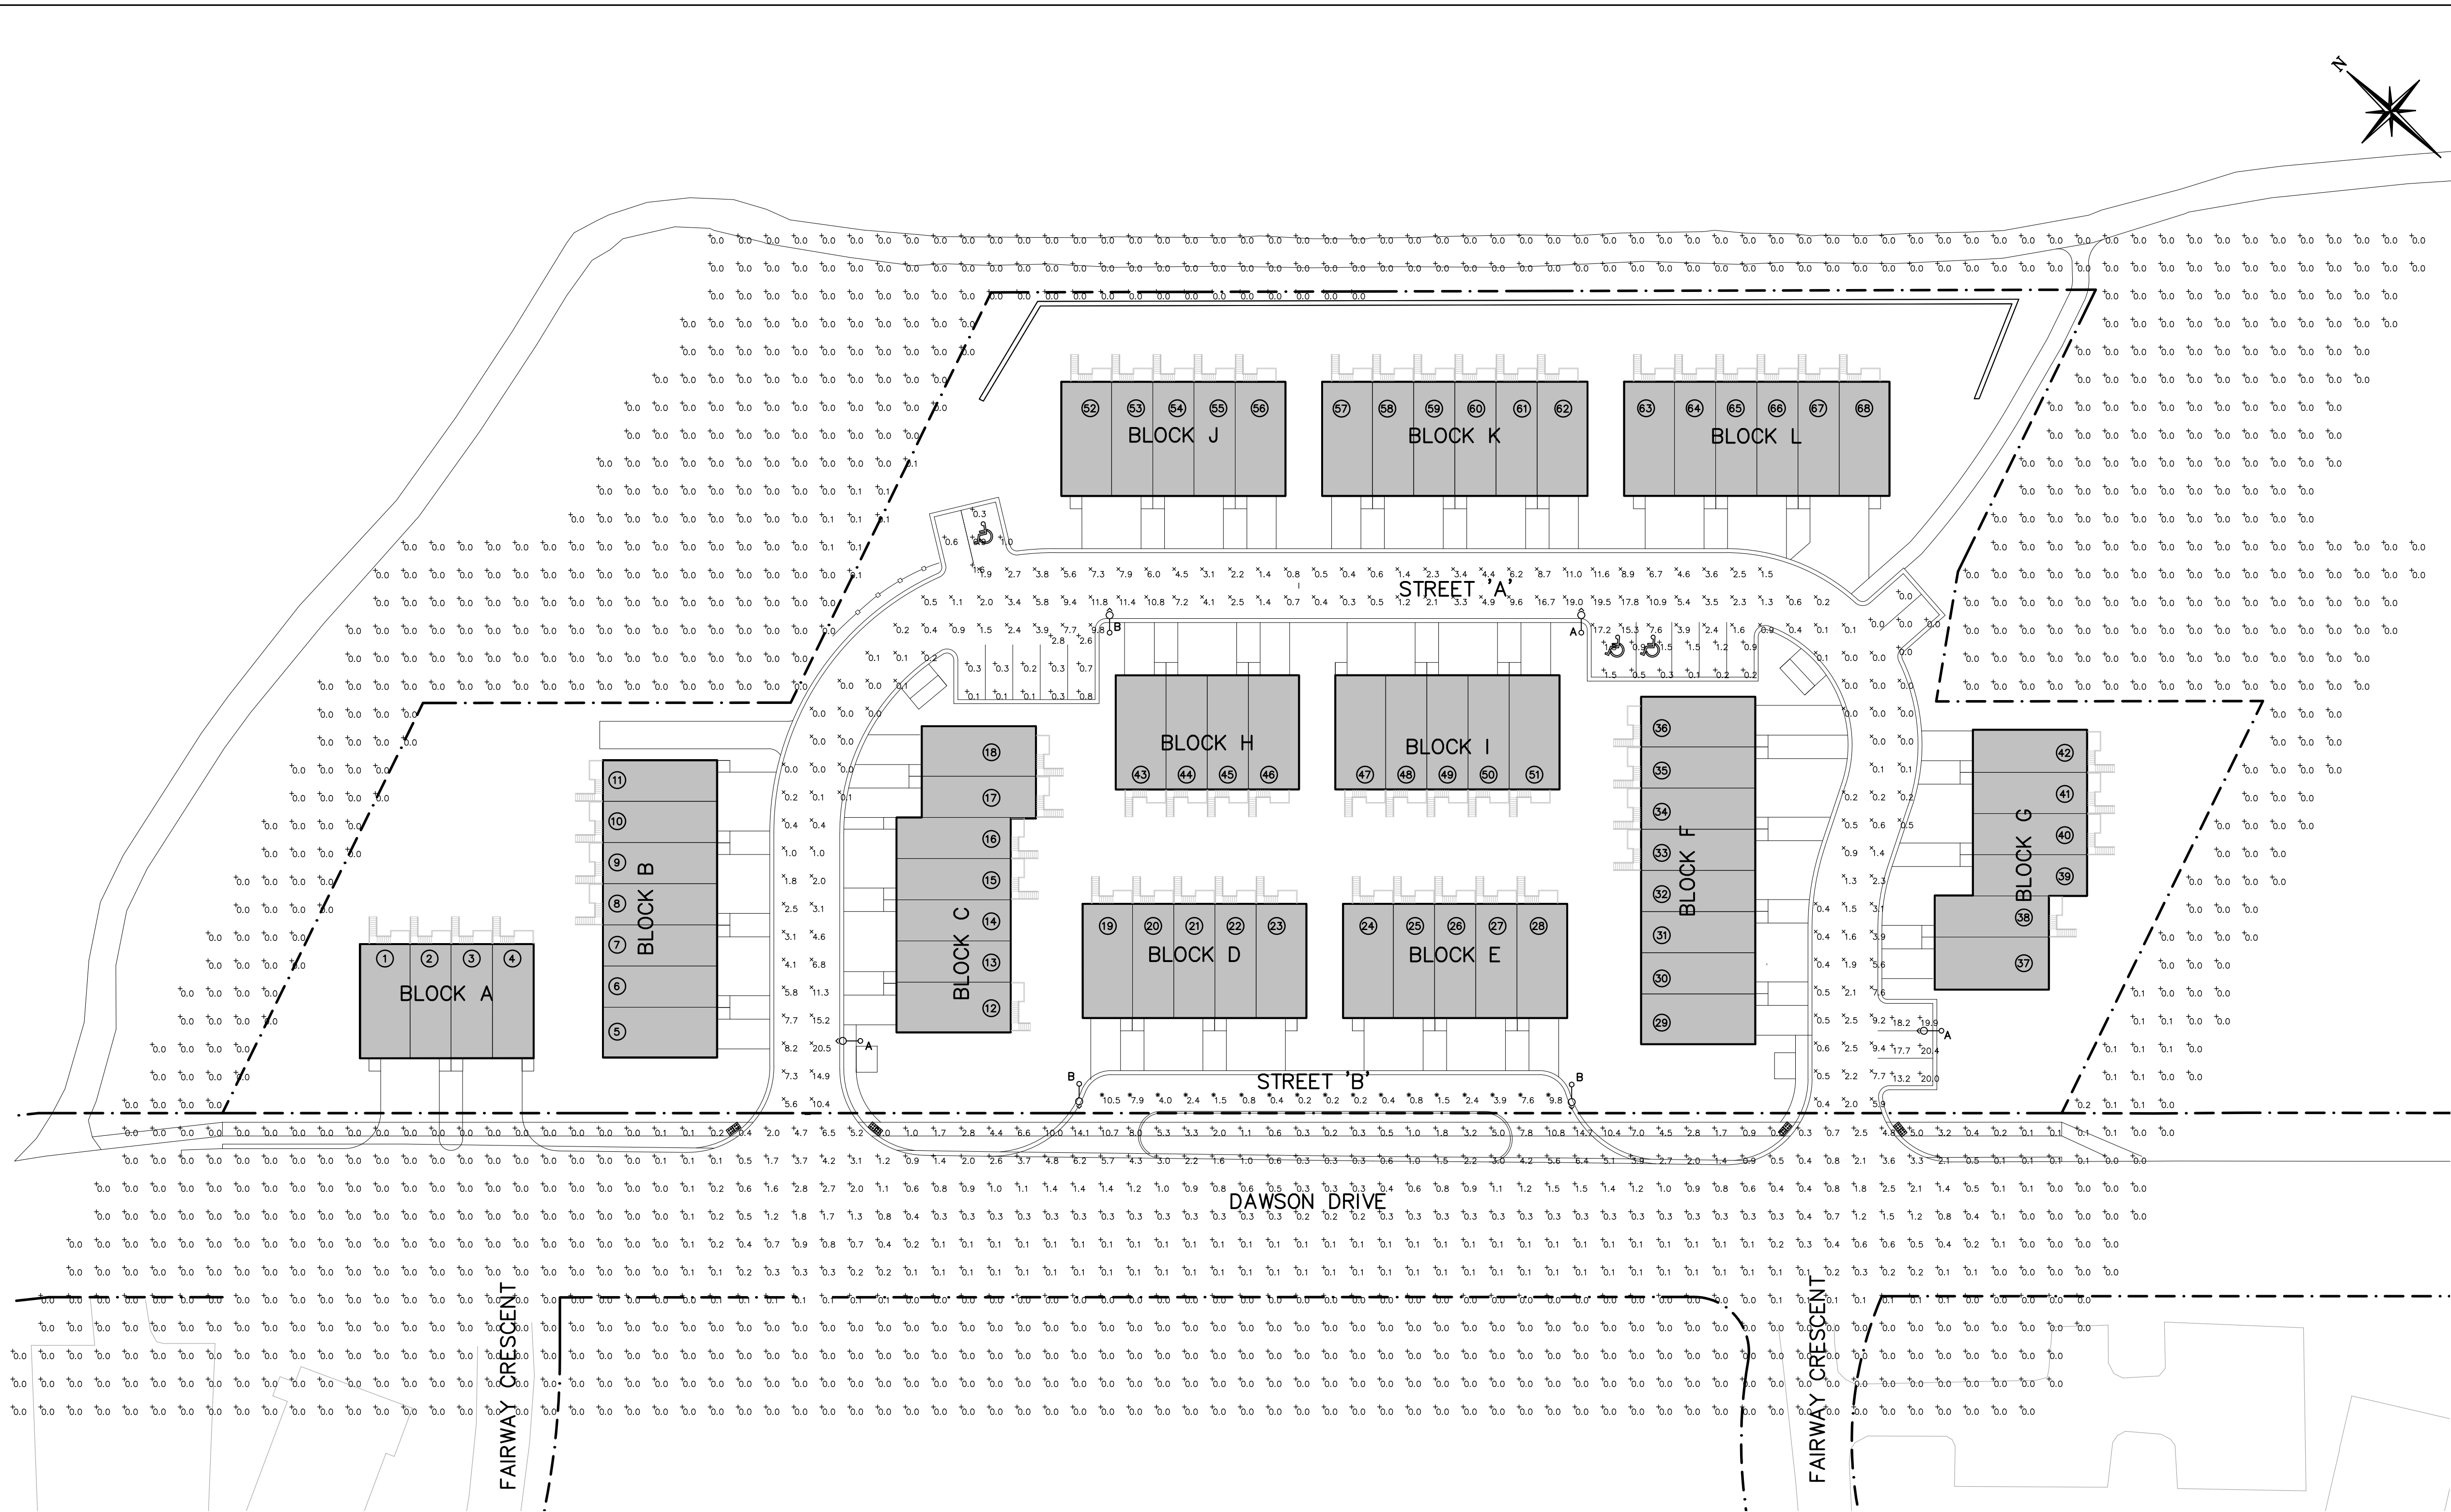

SITE PLAN – PHOTOMETRIC
SCALE: 1:400

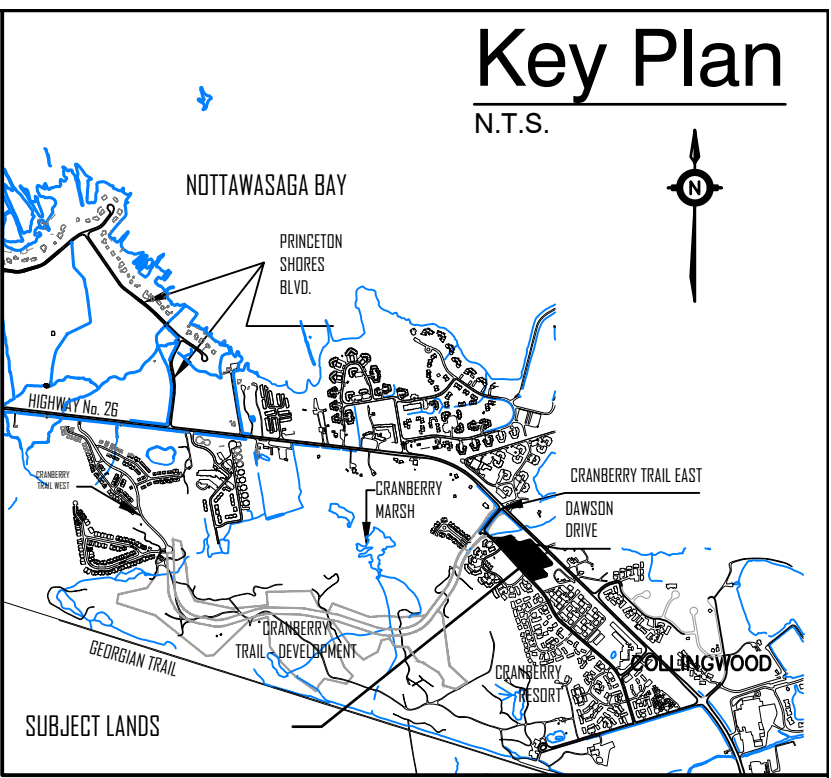


ELECTRICAL LEGEND	
LIGHTING	
	POLE MOUNTED LIGHT FIXTURE
LINETYPES	
	PROPERTY LINE

- THIS DRAWING IS THE EXCLUSIVE PROPERTY OF C.F. CROZIER & ASSOCIATES INC. AND THE REPRODUCTION OF ANY PART WITHOUT PRIOR WRITTEN CONSENT OF THIS OFFICE IS STRICTLY PROHIBITED.
- THE CONTRACTOR SHALL VERIFY ALL DIMENSIONS, LEVELS, AND DATUMS ON SITE AND REPORT ANY DISCREPANCIES OR OMISSIONS TO THIS OFFICE PRIOR TO CONSTRUCTION.
- THIS DRAWING IS TO BE READ AND UNDERSTOOD IN CONJUNCTION WITH ALL OTHER PLANS AND DOCUMENTS APPLICABLE TO THIS PROJECT.
- DO NOT SCALE THE DRAWINGS.
- ALL EXISTING UNDERGROUND UTILITIES TO BE VERIFIED IN THE FIELD BY THE CONTRACTOR PRIOR TO CONSTRUCTION.

Town

No.	Issue / Revision	Date: MM/DD/YYYY	Engineer
1	*NOT ISSUED FOR THIS SUBMISSION*	3/18/2008	
2	*NOT ISSUED FOR THIS SUBMISSION*	10/27/2009	
3	*NOT ISSUED FOR THIS SUBMISSION*	04/23/2012	
4	*NOT ISSUED FOR THIS SUBMISSION*	08/22/2012	
5	*NOT ISSUED FOR THIS SUBMISSION*	11/14/2012	
6	REVISED SITE PLAN	03/28/2019	
7	ISSUED FOR APPROVAL	04/12/2019	

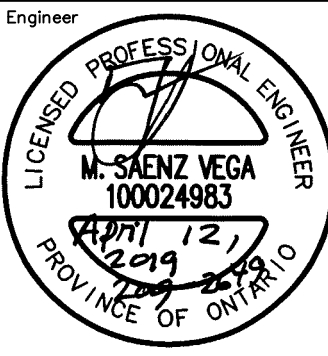

Project	WATERSTONE DEVELOPMENT TOWN of COLLINGWOOD	
Drawing	SITE PLAN – PHOTOMETRIC	



THE HARBOUREDGE BUILDING, 40 HURON STREET, SUITE 301, COLLINGWOOD, ON L9Y 4R3

Drawn By	N.B.	Check By	N.J.M./M.S.	Project No.	209-2649
Scale	1:400	Date	01/24/2019	Drawing No.	E100

