


STATISTICS SCHEDULE					
DESCRIPTION	SYMBOL	AVG	MAX	MIN	AVG/MIN
PARKING AREA	+	1.5 fc	6.7 fc	0.1 fc	14.8:1
PEDESTRIAN WALKWAY	X	6.8 fc	21.8 fc	0.3 fc	22.7:1

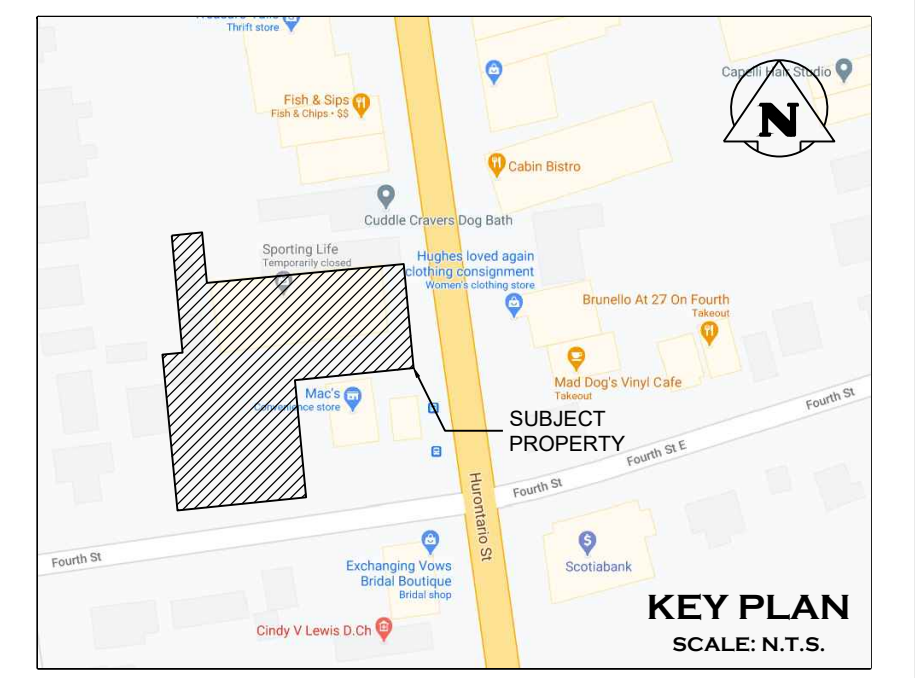

ELECTRICAL LEGEND	
LIGHTING	
	SINGLE POLE MOUNTED LIGHT FIXTURE
	WALL MOUNTED LIGHT FIXTURE
	EXISTING HYDRO POLE WITH NEW POLE MOUNTED TRANSFORMER
ABBREVIATIONS	
MH	MOUNTING HEIGHT
LINETYPES	
	PROPERTY LINE
	BUILDING LINE


ELECTRICAL DRAWING LIST	
E100	SITE PLAN - PHOTOMETRIC
E101	LIGHTING DETAILS AND SCHEDULES

No.	ISSUE / REVISION	DATE
0	ISSUED FOR SPA	11/25/2020
1	REISSUED FOR SITE PLAN APPROVAL	02/03/2021

North

Engineer

Engineer

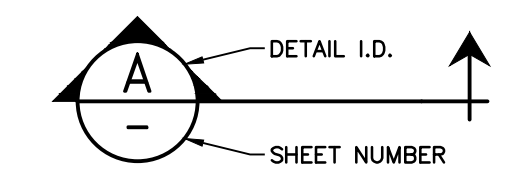

- THIS DRAWING IS THE EXCLUSIVE PROPERTY OF C.F. CROZIER & ASSOCIATES INC. AND THE REPRODUCTION OF ANY PART WITHOUT PRIOR WRITTEN CONSENT OF THIS OFFICE IS STRICTLY PROHIBITED.
- THE CONTRACTOR SHALL VERIFY ALL DIMENSIONS, LEVELS, AND DATUMS ON SITE AND REPORT ANY DISCREPANCIES OR OMISSIONS TO THIS OFFICE PRIOR TO CONSTRUCTION.
- THIS DRAWING IS TO BE READ AND UNDERSTOOD IN CONJUNCTION WITH ALL OTHER PLANS AND DOCUMENTS APPLICABLE TO THIS PROJECT.
- DO NOT SCALE THE DRAWINGS.
- ALL EXISTING UNDERGROUND UTILITIES TO BE VERIFIED IN THE FIELD BY THE CONTRACTOR PRIOR TO CONSTRUCTION.

Project

**SPORTING LIFE**  
222 HURONTARIO ST.  
COLLINGWOOD, ON

Drawing

**SITE PLAN-PHOTOMETRIC**

2800 HIGH POINT DRIVE  
SUITE 100  
MILTON, ON L9T 6P4  
905-875-0026 T  
905-875-4915 F  
WWW.CFCROZIER.CA

Drawn By	E.L.	Design By	I.S.	Project	<b>1956-5733</b>
Scale	1:200	Check By	M.S./N.J.M.	Drawing	<b>E100</b>

**SITE PLAN - PHOTOMETRIC**  
SCALE: 1:200